


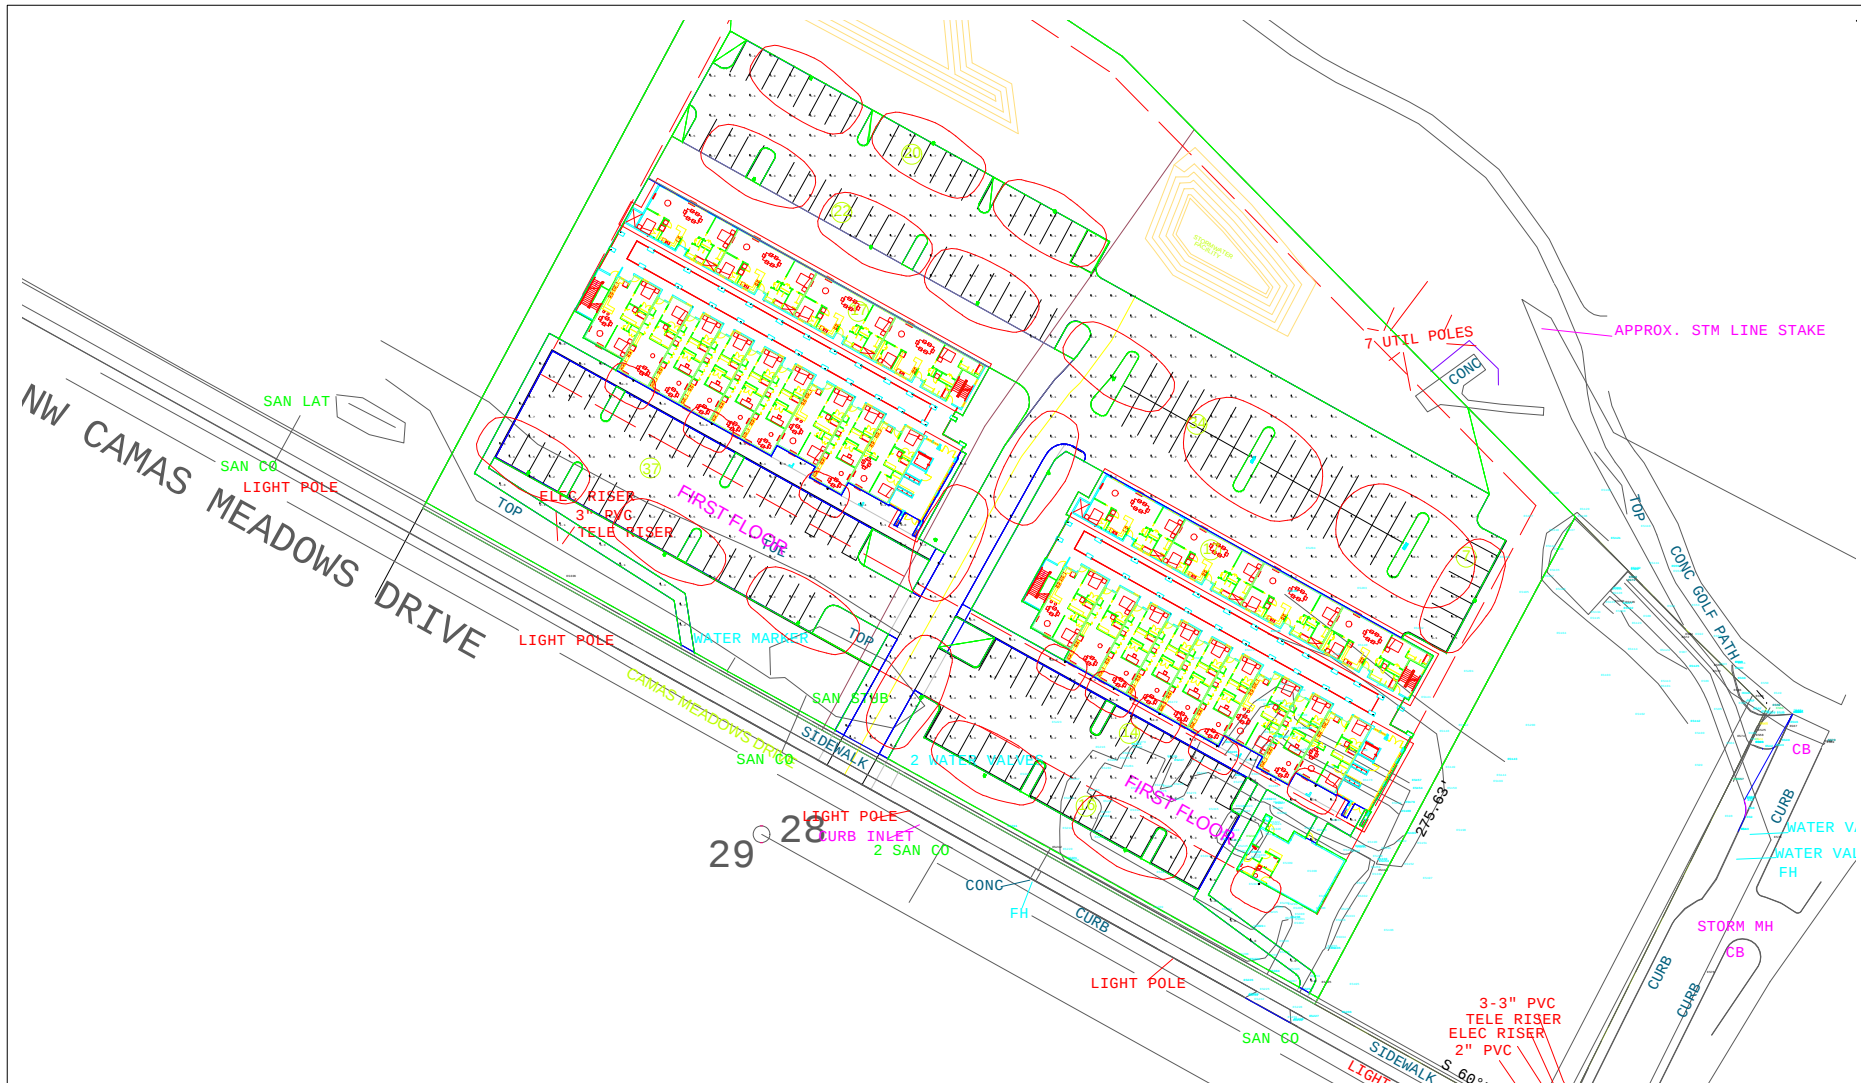

Luminaire Schedule

Symbol	Qty	Label	Arrangement	LLF	Lum. Lumens	Description
	16	KH40LC10X12U57K	SINGLE	0.900	12422	20'00\" AFF 4X4 POLE + KH40C10X12U57K
	9	TR2LC4X12U57K	SINGLE	0.900	3862	TR22LC4X12U57K
	2	KH40LC10X12U57K 2@180	BACK-BACK	0.900	12422	20'00\" AFF 4X4 POLE W/ TWO HEADS - KH40C


Calculation Summary

Label	CalcType	Units	Avg	Max	Min	Avg/Min	Max/Min
PARKING LOT_Planar	Illuminance	Fc	2.68	10.5	0.0	N.A.	N.A.
SIDWALK_2_Top	Illuminance	Fc	4.90	5.9	3.9	1.26	1.51
SIDWALK_3_Top	Illuminance	Fc	1.07	1.3	0.7	1.53	1.86
SIDWALK_4_Top	Illuminance	Fc	4.90	6.3	3.5	1.40	1.80
SIDWALK_6_Top	Illuminance	Fc	2.93	12.0	0.0	N.A.	N.A.
SIDWALK_Top	Illuminance	Fc	1.99	11.4	0.0	N.A.	N.A.

#	Date	Comments

Drawn By:	Checked By:	Date: 3/4/2015	Scale:

CAMAS LOFT- PARKING LOT

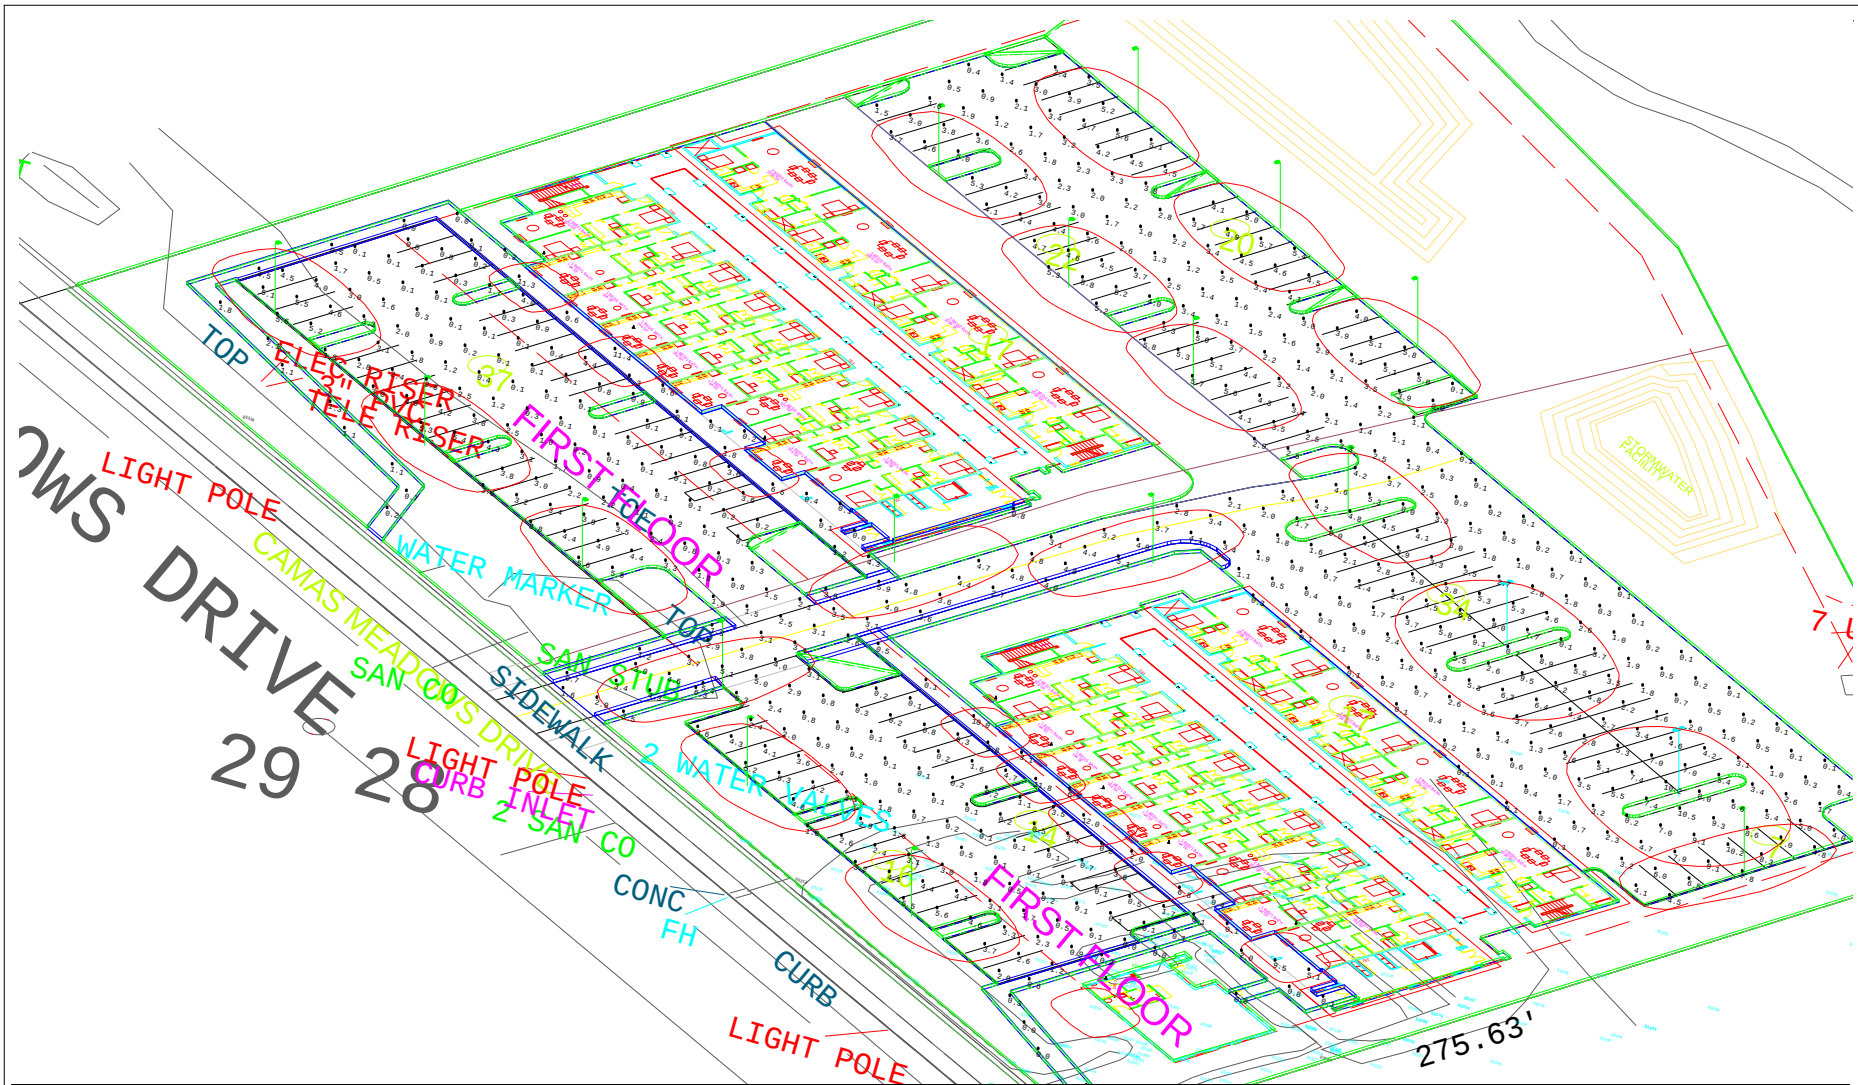


Luminaire Schedule								
Symbol	Qty	Label	Arrangement	LLF	Lum. Lumens	Description		
	16	KH40LC10X12U57K	SINGLE	0.900	12422	20F00T AFF 4X4 POLE + KH40C10X12U57K		
	9	TR2LC4X12U57K	SINGLE	0.900	3862	TR22LC4X12U57K		
	2	KH40LC10X12U57K 2@180	BACK-BACK	0.900	12422	20F00T AFF 4X4 POLE W/ TWO HEADS - KH40C		
Calculation Summary								
Label	CalcType	Units	Avg	Max	Min	Avg/Min		Max/Min
PARKING LOT_Planar	Illuminance	Fc	2.68	10.5	0.0	N.A.		N.A.
SIDWALK_2_Top	Illuminance	Fc	4.90	5.9	3.9	1.26		1.51
SIDWALK_3_Top	Illuminance	Fc	1.07	1.3	0.7	1.53		1.86
SIDWALK_4_Top	Illuminance	Fc	4.90	6.3	3.5	1.40		1.80
SIDWALK_6_Top	Illuminance	Fc	2.93	12.0	0.0	N.A.		N.A.
SIDWALK_Top	Illuminance	Fc	1.99	11.4	0.0	N.A.		N.A.

#	Date	Comments
Revisions		

Drawn By:	Checked By:	Date: 3/4/2015	Scale:
-----------	-------------	----------------	--------

CAMAS LOFT- PARKING LOT

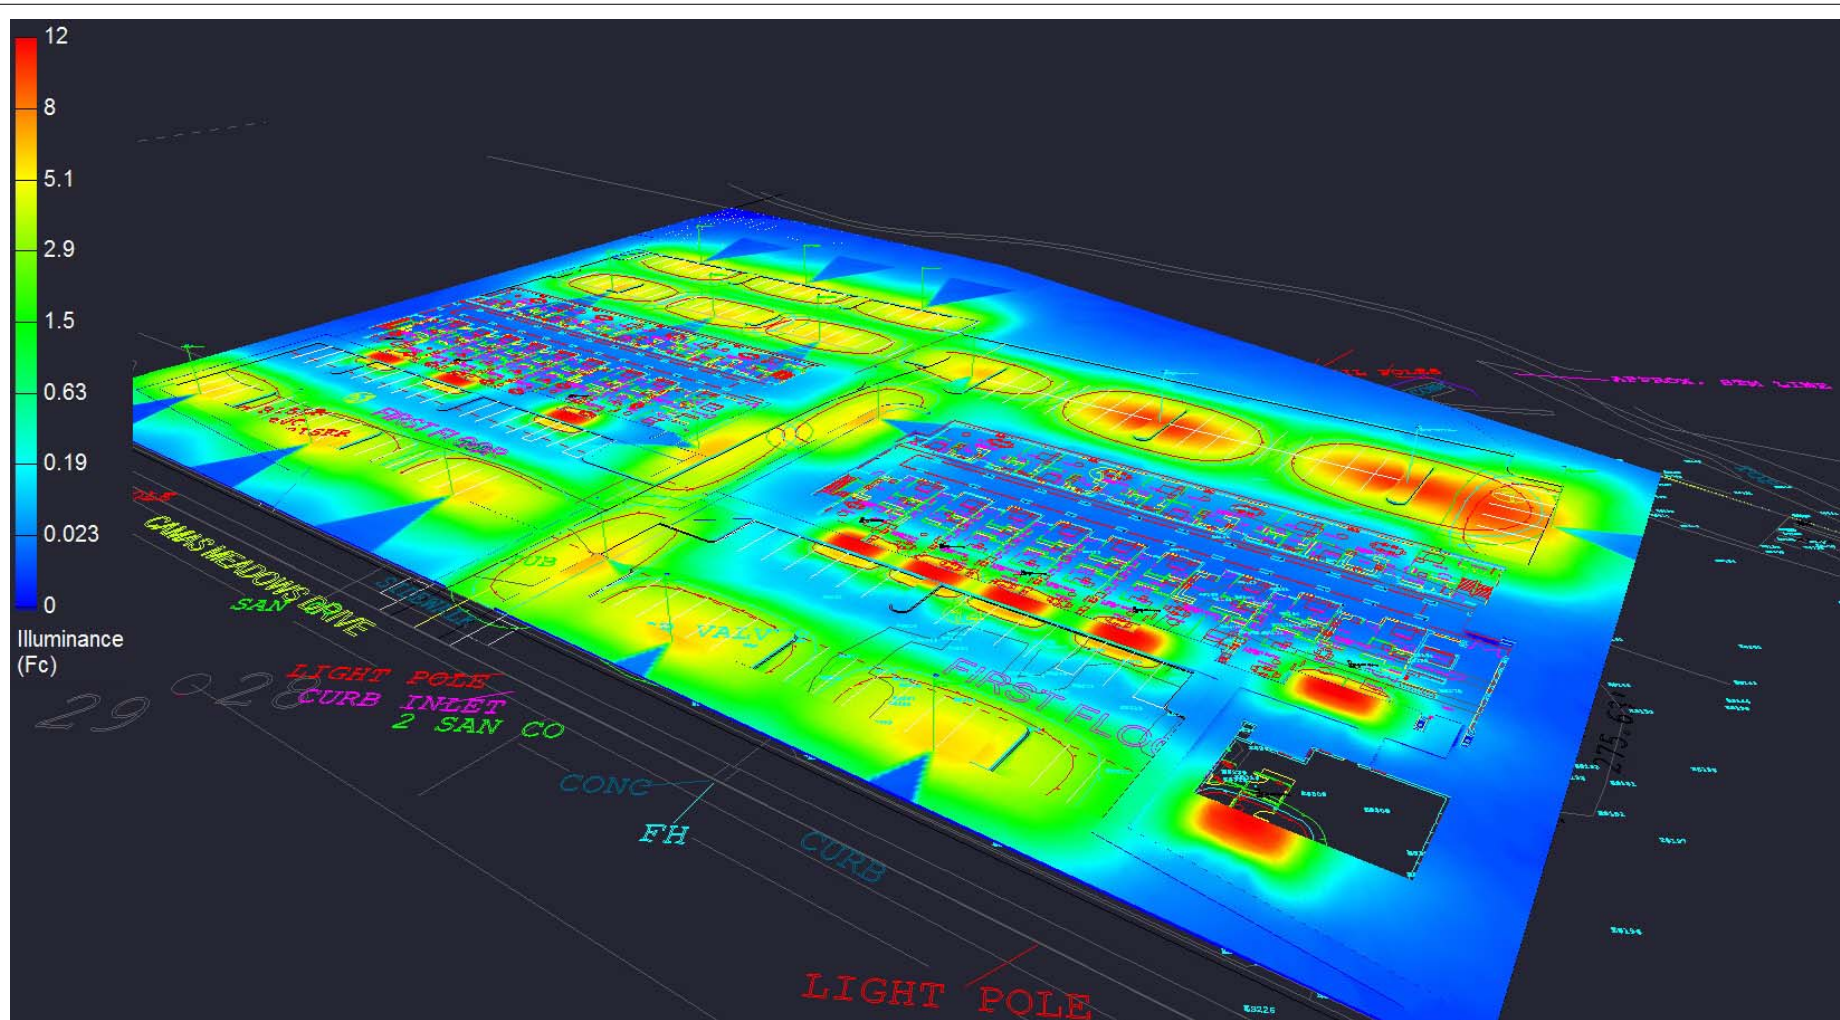

Luminaire Schedule

Symbol	Qty	Label	Arrangement	LLF	Lum. Lumens	Description
	16	KH40LC10X12U57K	SINGLE	0.900	12422	20'00" AFF 4X4 POLE + KH40C10X12U57K
	9	TR2LC4X12U57K	SINGLE	0.900	3862	TR22LC4X12U57K
	2	KH40LC10X12U57K 2@180	BACK-BACK	0.900	12422	20'00" AFF 4X4 POLE W/ TWO HEADS - KH40C


Calculation Summary

Label	CalcType	Units	Avg	Max	Min	Avg/Min	Max/Min
PARKING LOT_Planar	Illuminance	Fc	2.68	10.5	0.0	N.A.	N.A.
SIDWALK_2_Top	Illuminance	Fc	4.90	5.9	3.9	1.26	1.51
SIDWALK_3_Top	Illuminance	Fc	1.07	1.3	0.7	1.53	1.86
SIDWALK_4_Top	Illuminance	Fc	4.90	6.3	3.5	1.40	1.80
SIDWALK_6_Top	Illuminance	Fc	2.93	12.0	0.0	N.A.	N.A.
SIDWALK_Top	Illuminance	Fc	1.99	11.4	0.0	N.A.	N.A.

#	Date	Comments

Drawn By:	Checked By:	Date: 3/4/2015	Scale:

CAMAS LOFT- PARKING LOT

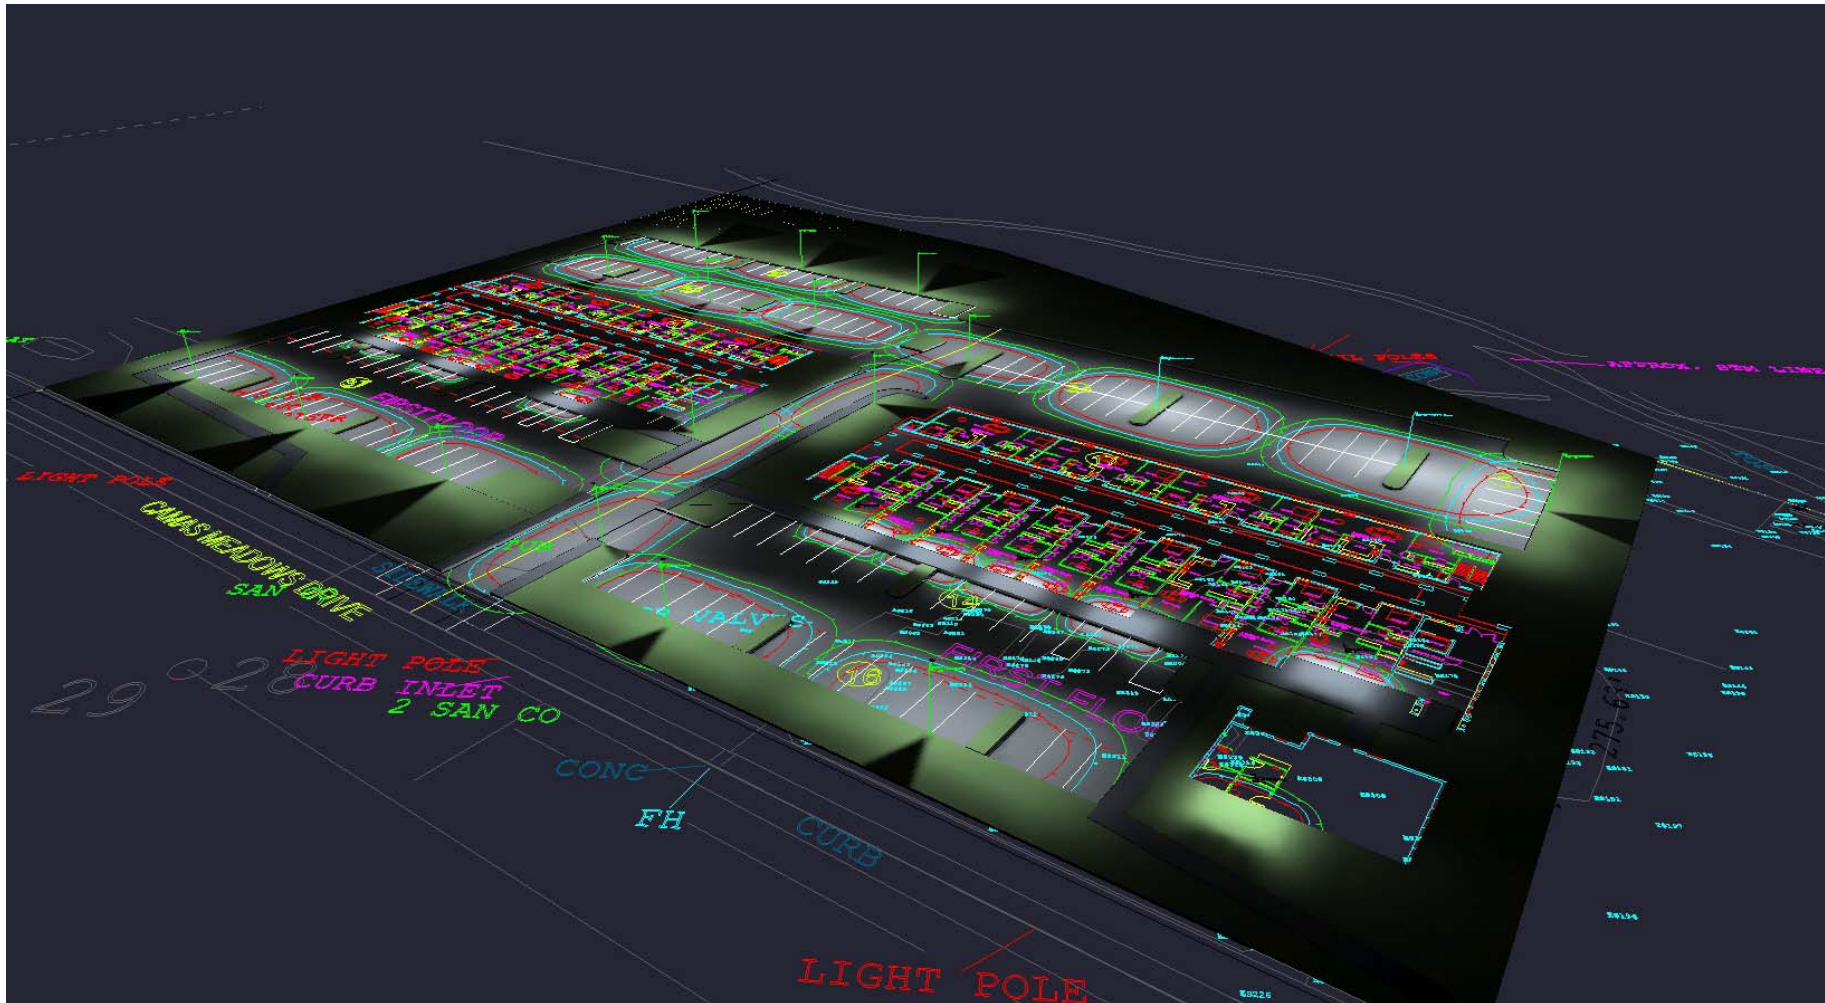

Luminaire Schedule

Symbol	Qty	Label	Arrangement	LLF	Lum. Lumens	Description
	16	KH40LC10X12U57K	SINGLE	0.900	12422	20FOOT AFF 4X4 POLE + KH40C10X12U57K
	9	TR2LC4X12U57K	SINGLE	0.900	3862	TR22LC4X12U57K
	2	KH40LC10X12U57K 2@180	BACK-BACK	0.900	12422	20FOOT AFF 4X4 POLE W/ TWO HEADS - KH40C


Calculation Summary

Label	CalcType	Units	Avg	Max	Min	Avg/Min	Max/Min
PARKING LOT_Planar	Illuminance	Fc	2.68	10.5	0.0	N.A.	N.A.
SIDWALK_2_Top	Illuminance	Fc	4.90	5.9	3.9	1.26	1.51
SIDWALK_3_Top	Illuminance	Fc	1.07	1.3	0.7	1.53	1.86
SIDWALK_4_Top	Illuminance	Fc	4.90	6.3	3.5	1.40	1.80
SIDWALK_6_Top	Illuminance	Fc	2.93	12.0	0.0	N.A.	N.A.
SIDWALK_Top	Illuminance	Fc	1.99	11.4	0.0	N.A.	N.A.

#	Date	Comments

Drawn By:	Checked By:	Date: 3/4/2015	Scale:

CAMAS LOFT- PARKING LOT

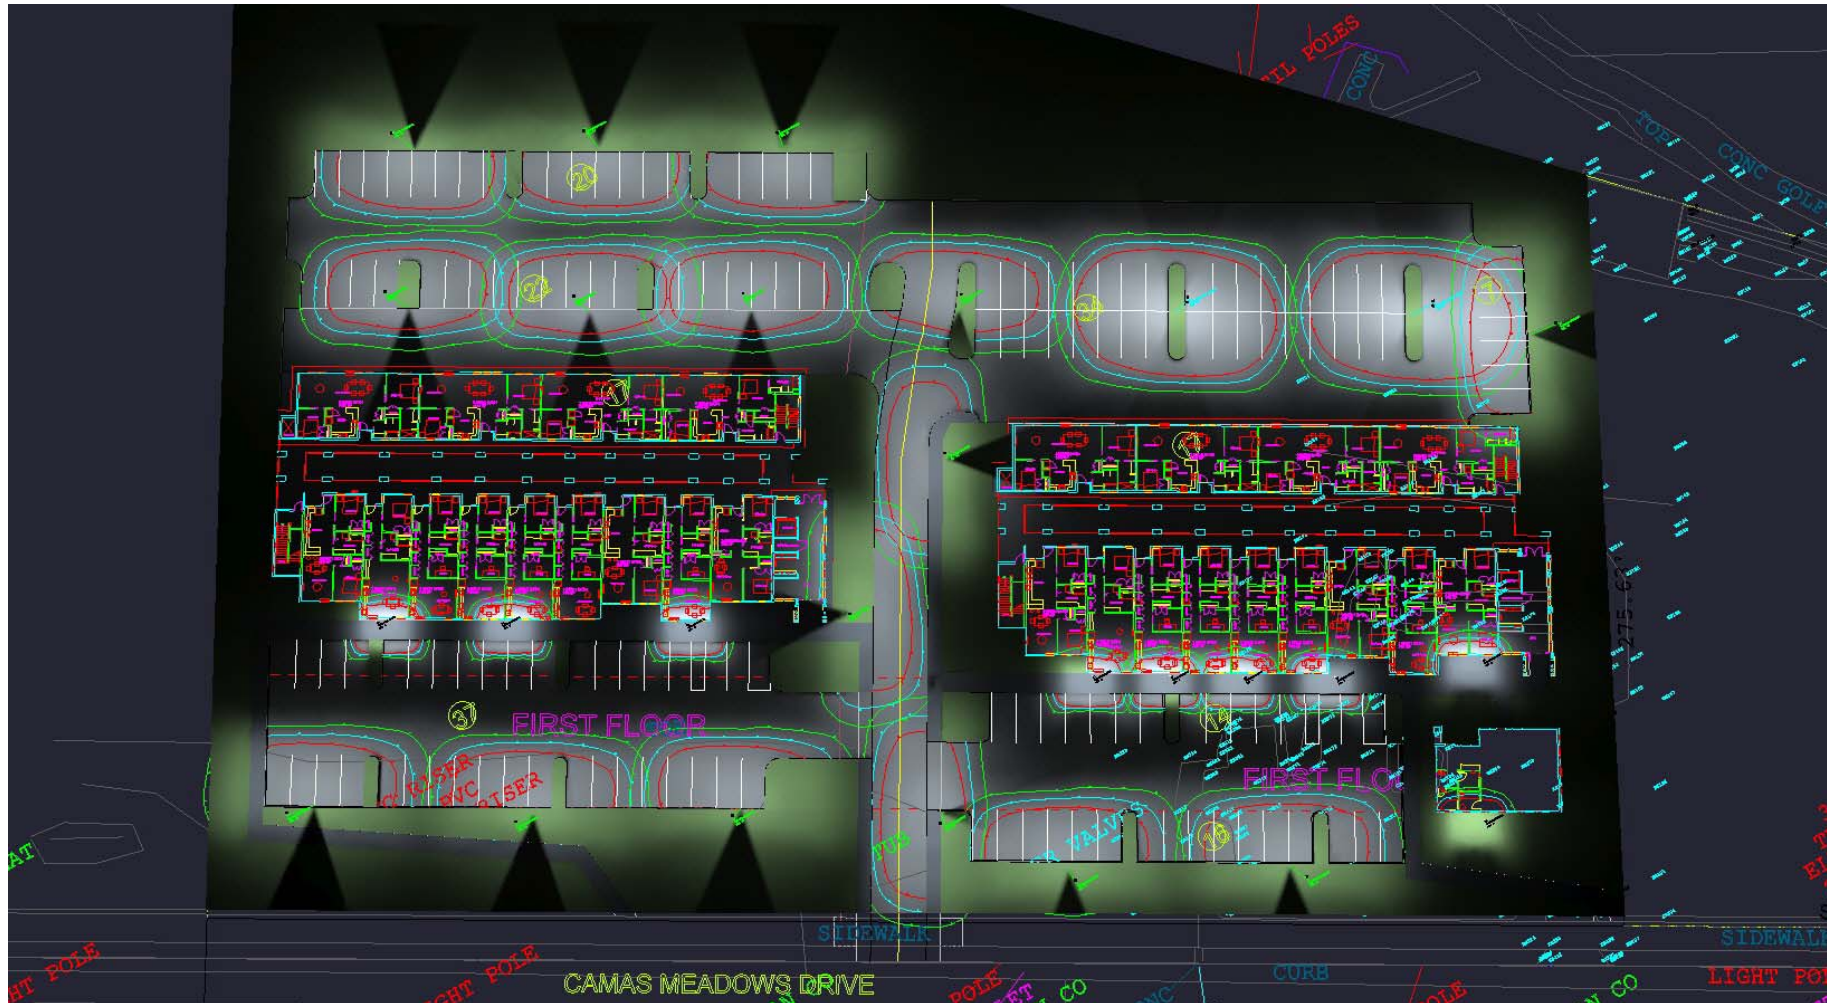

Luminaire Schedule

Symbol	Qty	Label	Arrangement	LLF	Lum. Lumens	Description
	16	KH40LC10X12U57K	SINGLE	0.900	12422	20FOOT AFF 4X4 POLE + KH40C10X12U57K
	9	TR2LC4X12U57K	SINGLE	0.900	3862	TR22LC4X12U57K
	2	KH40LC10X12U57K 2@180	BACK-BACK	0.900	12422	20FOOT AFF 4X4 POLE W/ TWO HEADS - KH40C

Calculation Summary

Label	CalcType	Units	Avg	Max	Min	Avg/Min	Max/Min
PARKING LOT_Planar	Illuminance	Fc	2.68	10.5	0.0	N.A.	N.A.
SIDWALK_2_Top	Illuminance	Fc	4.90	5.9	3.9	1.26	1.51
SIDWALK_3_Top	Illuminance	Fc	1.07	1.3	0.7	1.53	1.86
SIDWALK_4_Top	Illuminance	Fc	4.90	6.3	3.5	1.40	1.80
SIDWALK_6_Top	Illuminance	Fc	2.93	12.0	0.0	N.A.	N.A.
SIDWALK_Top	Illuminance	Fc	1.99	11.4	0.0	N.A.	N.A.

#	Date	Comments

Drawn By:	Checked By:	Date: 3/4/2015	Scale:

CAMAS LOFT- PARKING LOT