


APPENDIX 1

DESIGN REVIEW

REVISED 1/17/17



SHEET INDEX

L1.0 LANDSCAPE SITE PLAN
L1.1 LANDSCAPE PLANTING AND HARDSCAPE PLAN 1
L1.2 LANDSCAPE PLANTING AND HARDSCAPE PLAN 2
L1.3 LANDSCAPE PLANTING AND HARDSCAPE PLAN 3
L1.4 LANDSCAPE PLANTING AND HARDSCAPE PLAN 4
L1.5 LANDSCAPE PLANTING AND HARDSCAPE PLAN 5
A1.1 OVERALL FLOOR PLANS - LEVEL 1
A1.2 OVERALL FLOOR PLANS - LEVEL 2
SD 5.3 EXTERIOR ELEVATIONS
SD 5.4 EXTERIOR ELEVATIONS
E0.3 SITE PLAN - ELECTRICAL
E0.4 SITE PLAN - LIGHTING
E0.5 SITE PLAN - LIGHTING

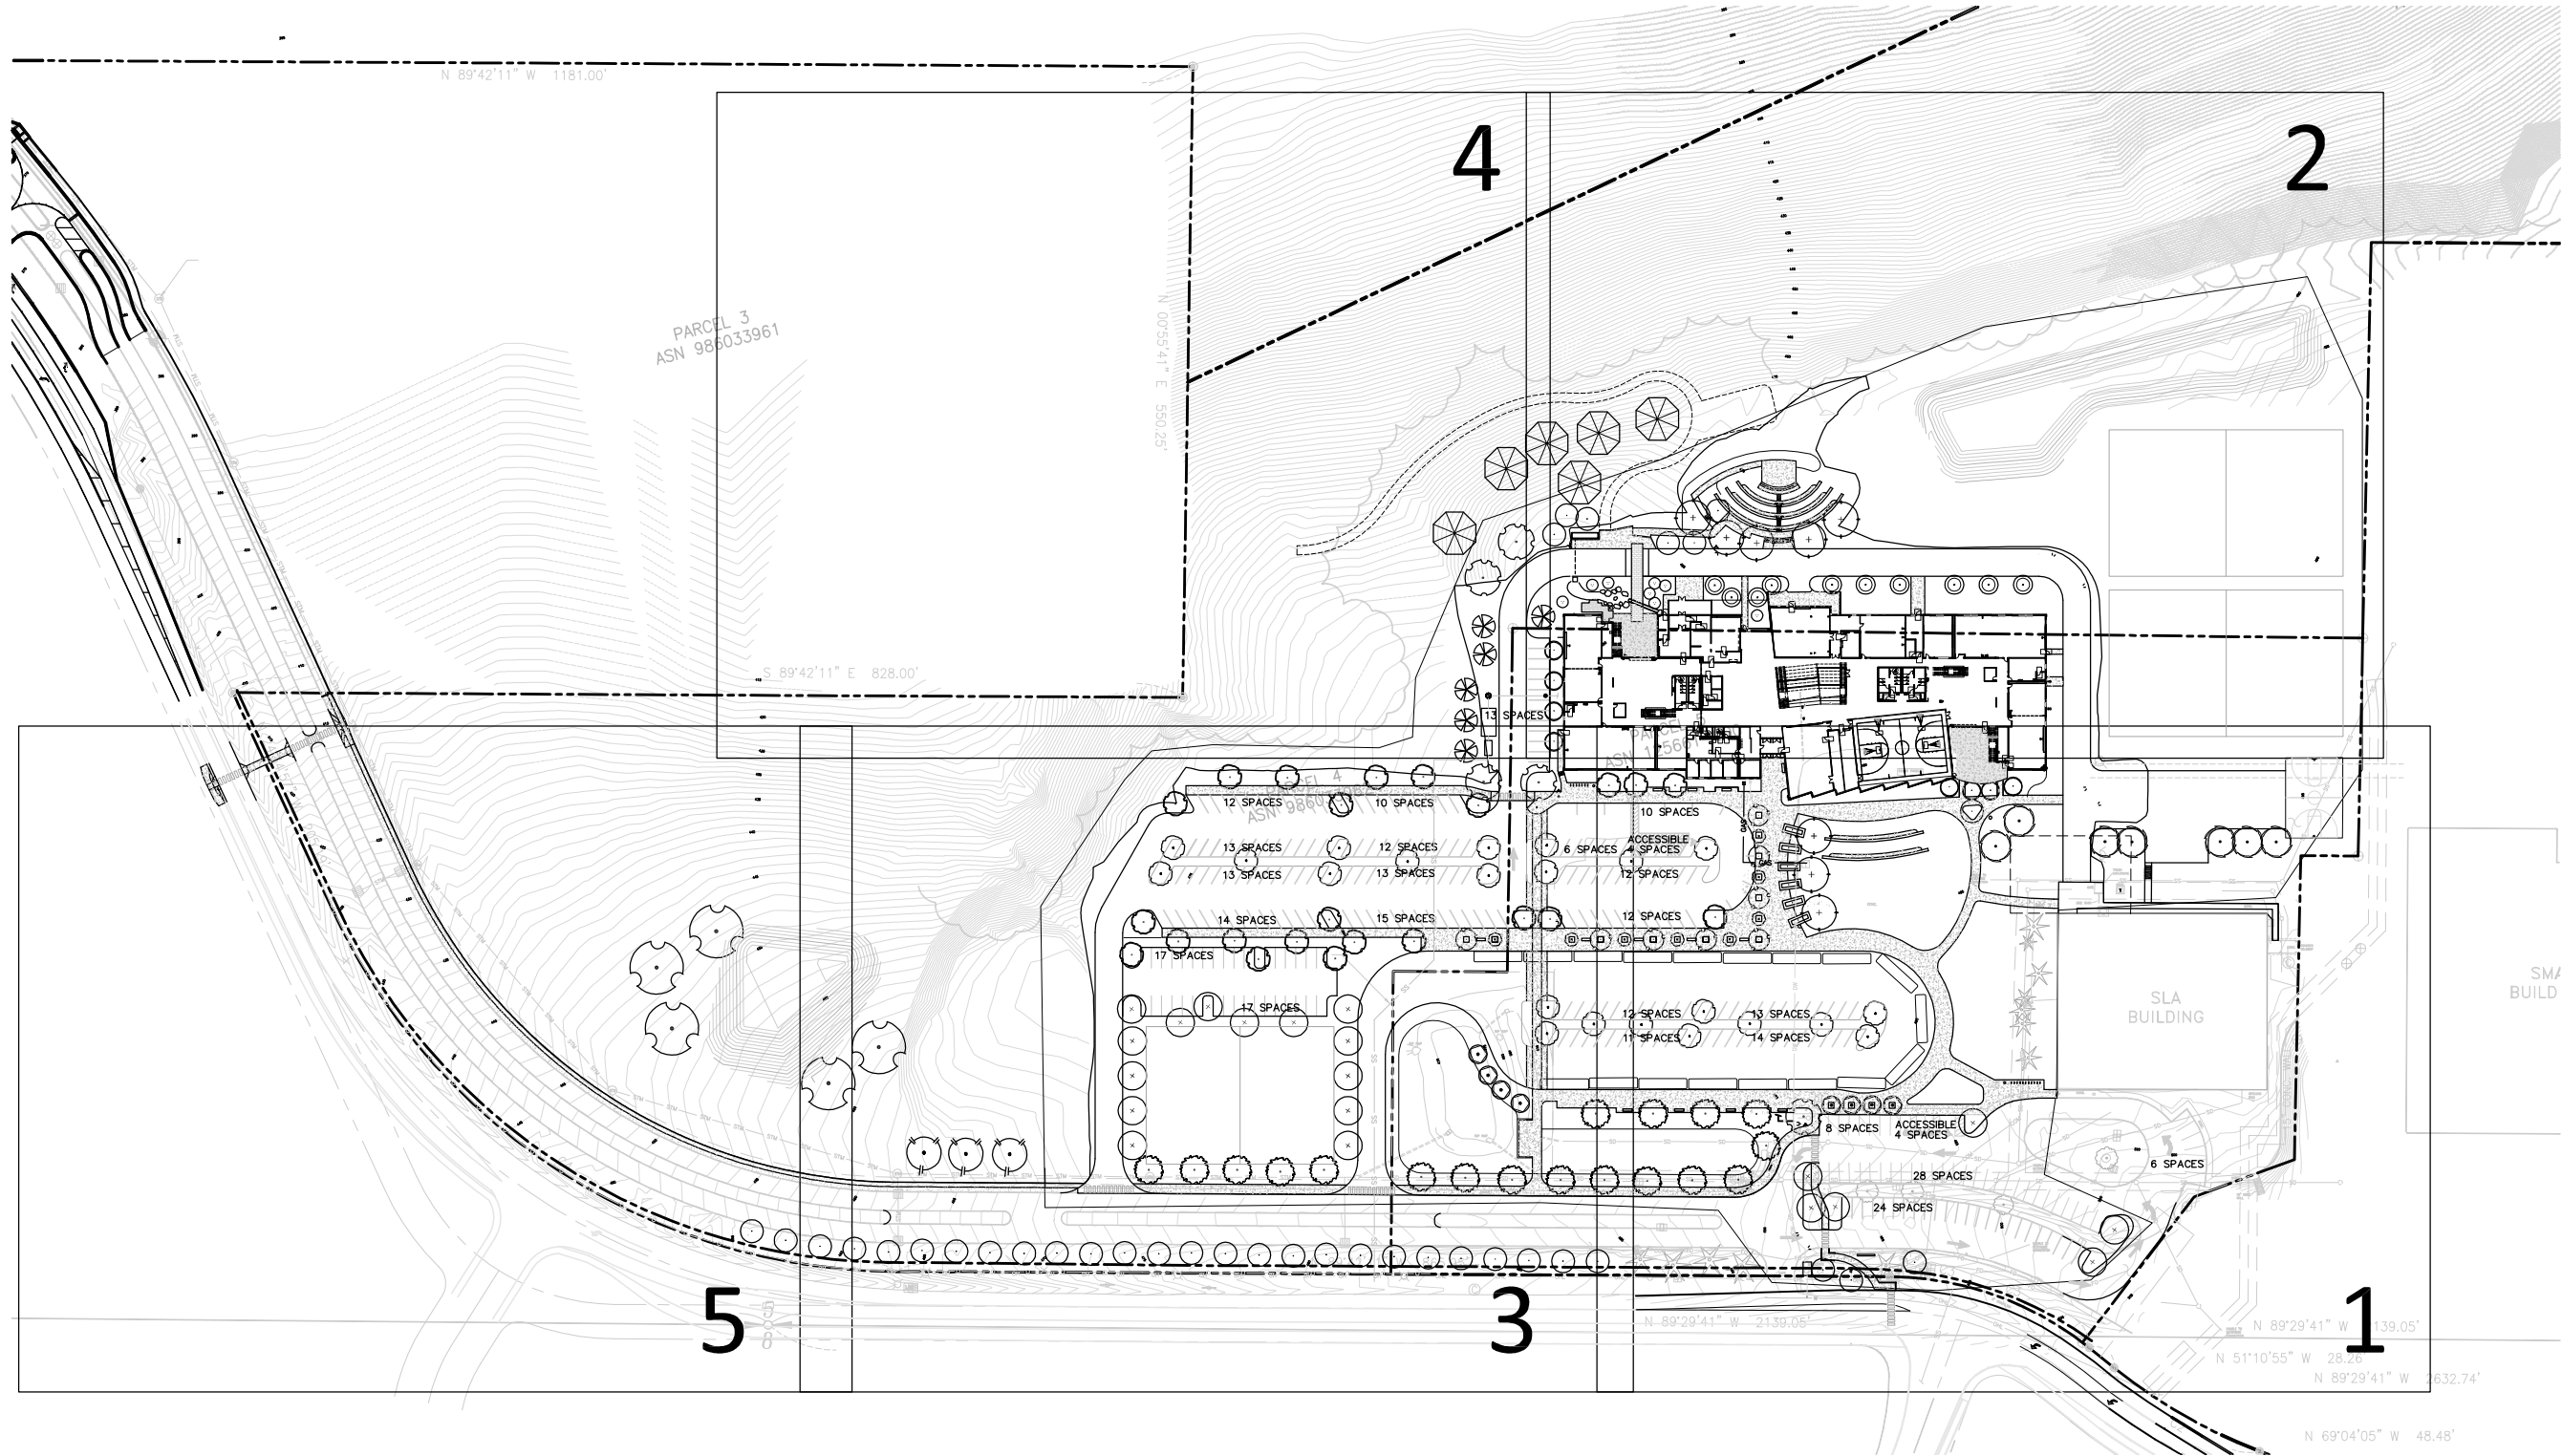

PARKING COUNTS			
REQUIRED		PROVIDED	
ACCESSIBLE STALLS*	8	ACCESSIBLE STALLS*	8
STAFF	90	STAFF	106
STUDENT	150	STUDENT	192
VISITOR	20	VISITOR	20
TOTAL STD STALLS**	260	TOTAL STD STALLS	318
* City of Camas municipal development code (CM C)			
** Camas School District requirement (exceeds CM C)			



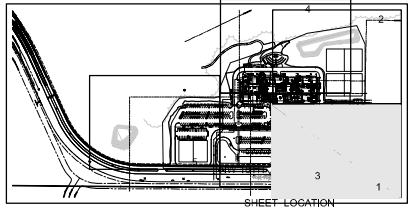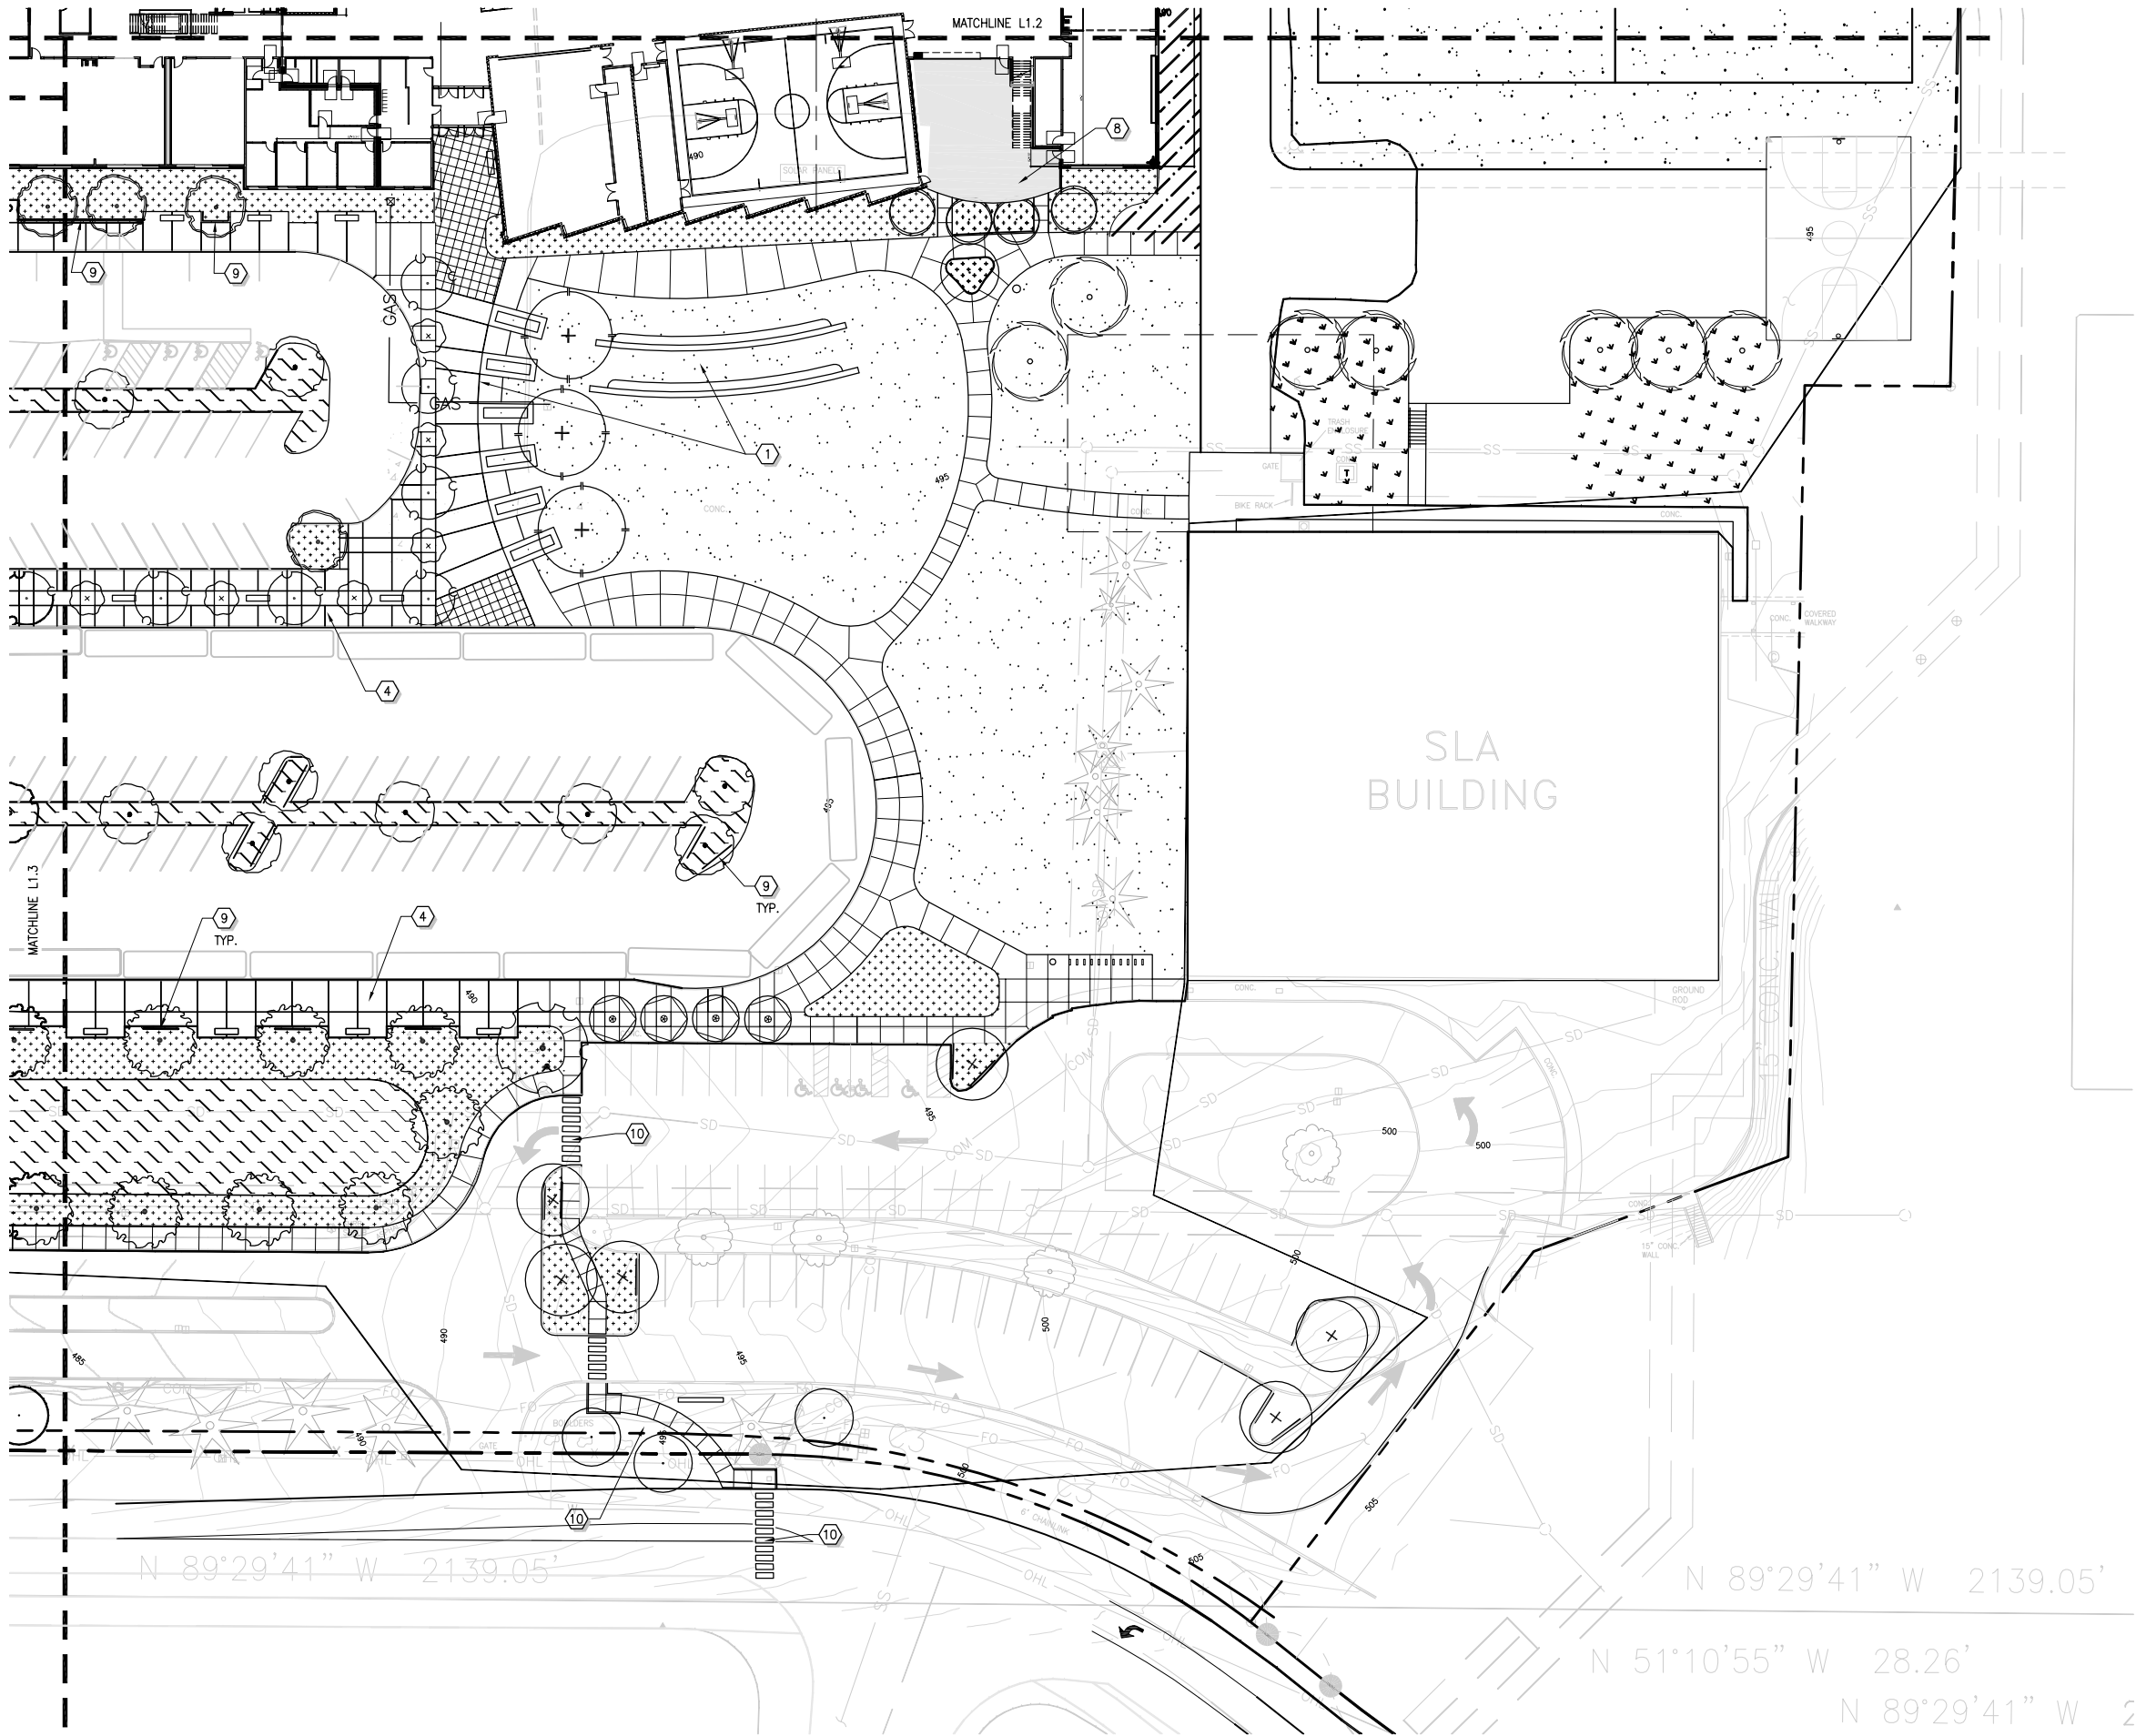

GENERAL NOTES


1. ALL LANDSCAPED AREAS TO BE WATERED BY A FULLY AUTOMATIC UNDERGROUND IRRIGATION SYSTEM.
2. PLANT MATERIAL LEGEND: SEE SHEET L1.4
3. LANDSCAPE INSTALLATION NOTES AND DETAILS: SEE SHEET L4.1 TO L4.8



CONSTRUCTION NOTES

- ① ENTRY COMMONS AREA. SEE SHEET L3.1
- ② HARD SURFACE PLAYGROUND AREA. SEE SHEET L3.3
- ③ PEDESTRIAN CROSSING AREA. SEE SHEET L3.1
- ④ BUS LOADING AREA. SEE SHEET L3.1
- ⑤ AMPHITHEATER AREA. SEE SHEET L3.2
- ⑥ STORMWATER GARDEN AREA. SEE SHEET L3.2
- ⑦ OUTDOOR LEARNING AREA. SEE SHEET L3.2
- ⑧ OUTDOOR LEARNING AREA. SEE SHEET L3.1
- ⑨ INSTALL 12 LF ROOT BARRIER WHERE INDICATED. SEE SHEET L4.1
- ⑩ PEDESTRIAN CROSSING AREA AT MIDDLE SCHOOL. SEE SHEET L3.3
- ⑪ STORM POND OVERLOOK WITH RAILING. SEE SHEET L3.3

LEGEND

- EXISTING EVERGREEN TREE TO REMAIN
- EXISTING DECIDUOUS TREE TO REMAIN

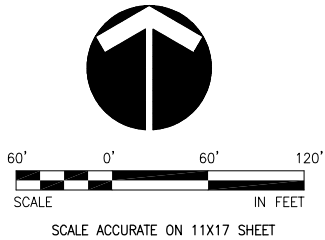

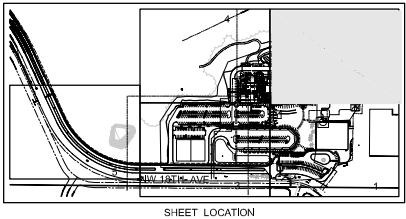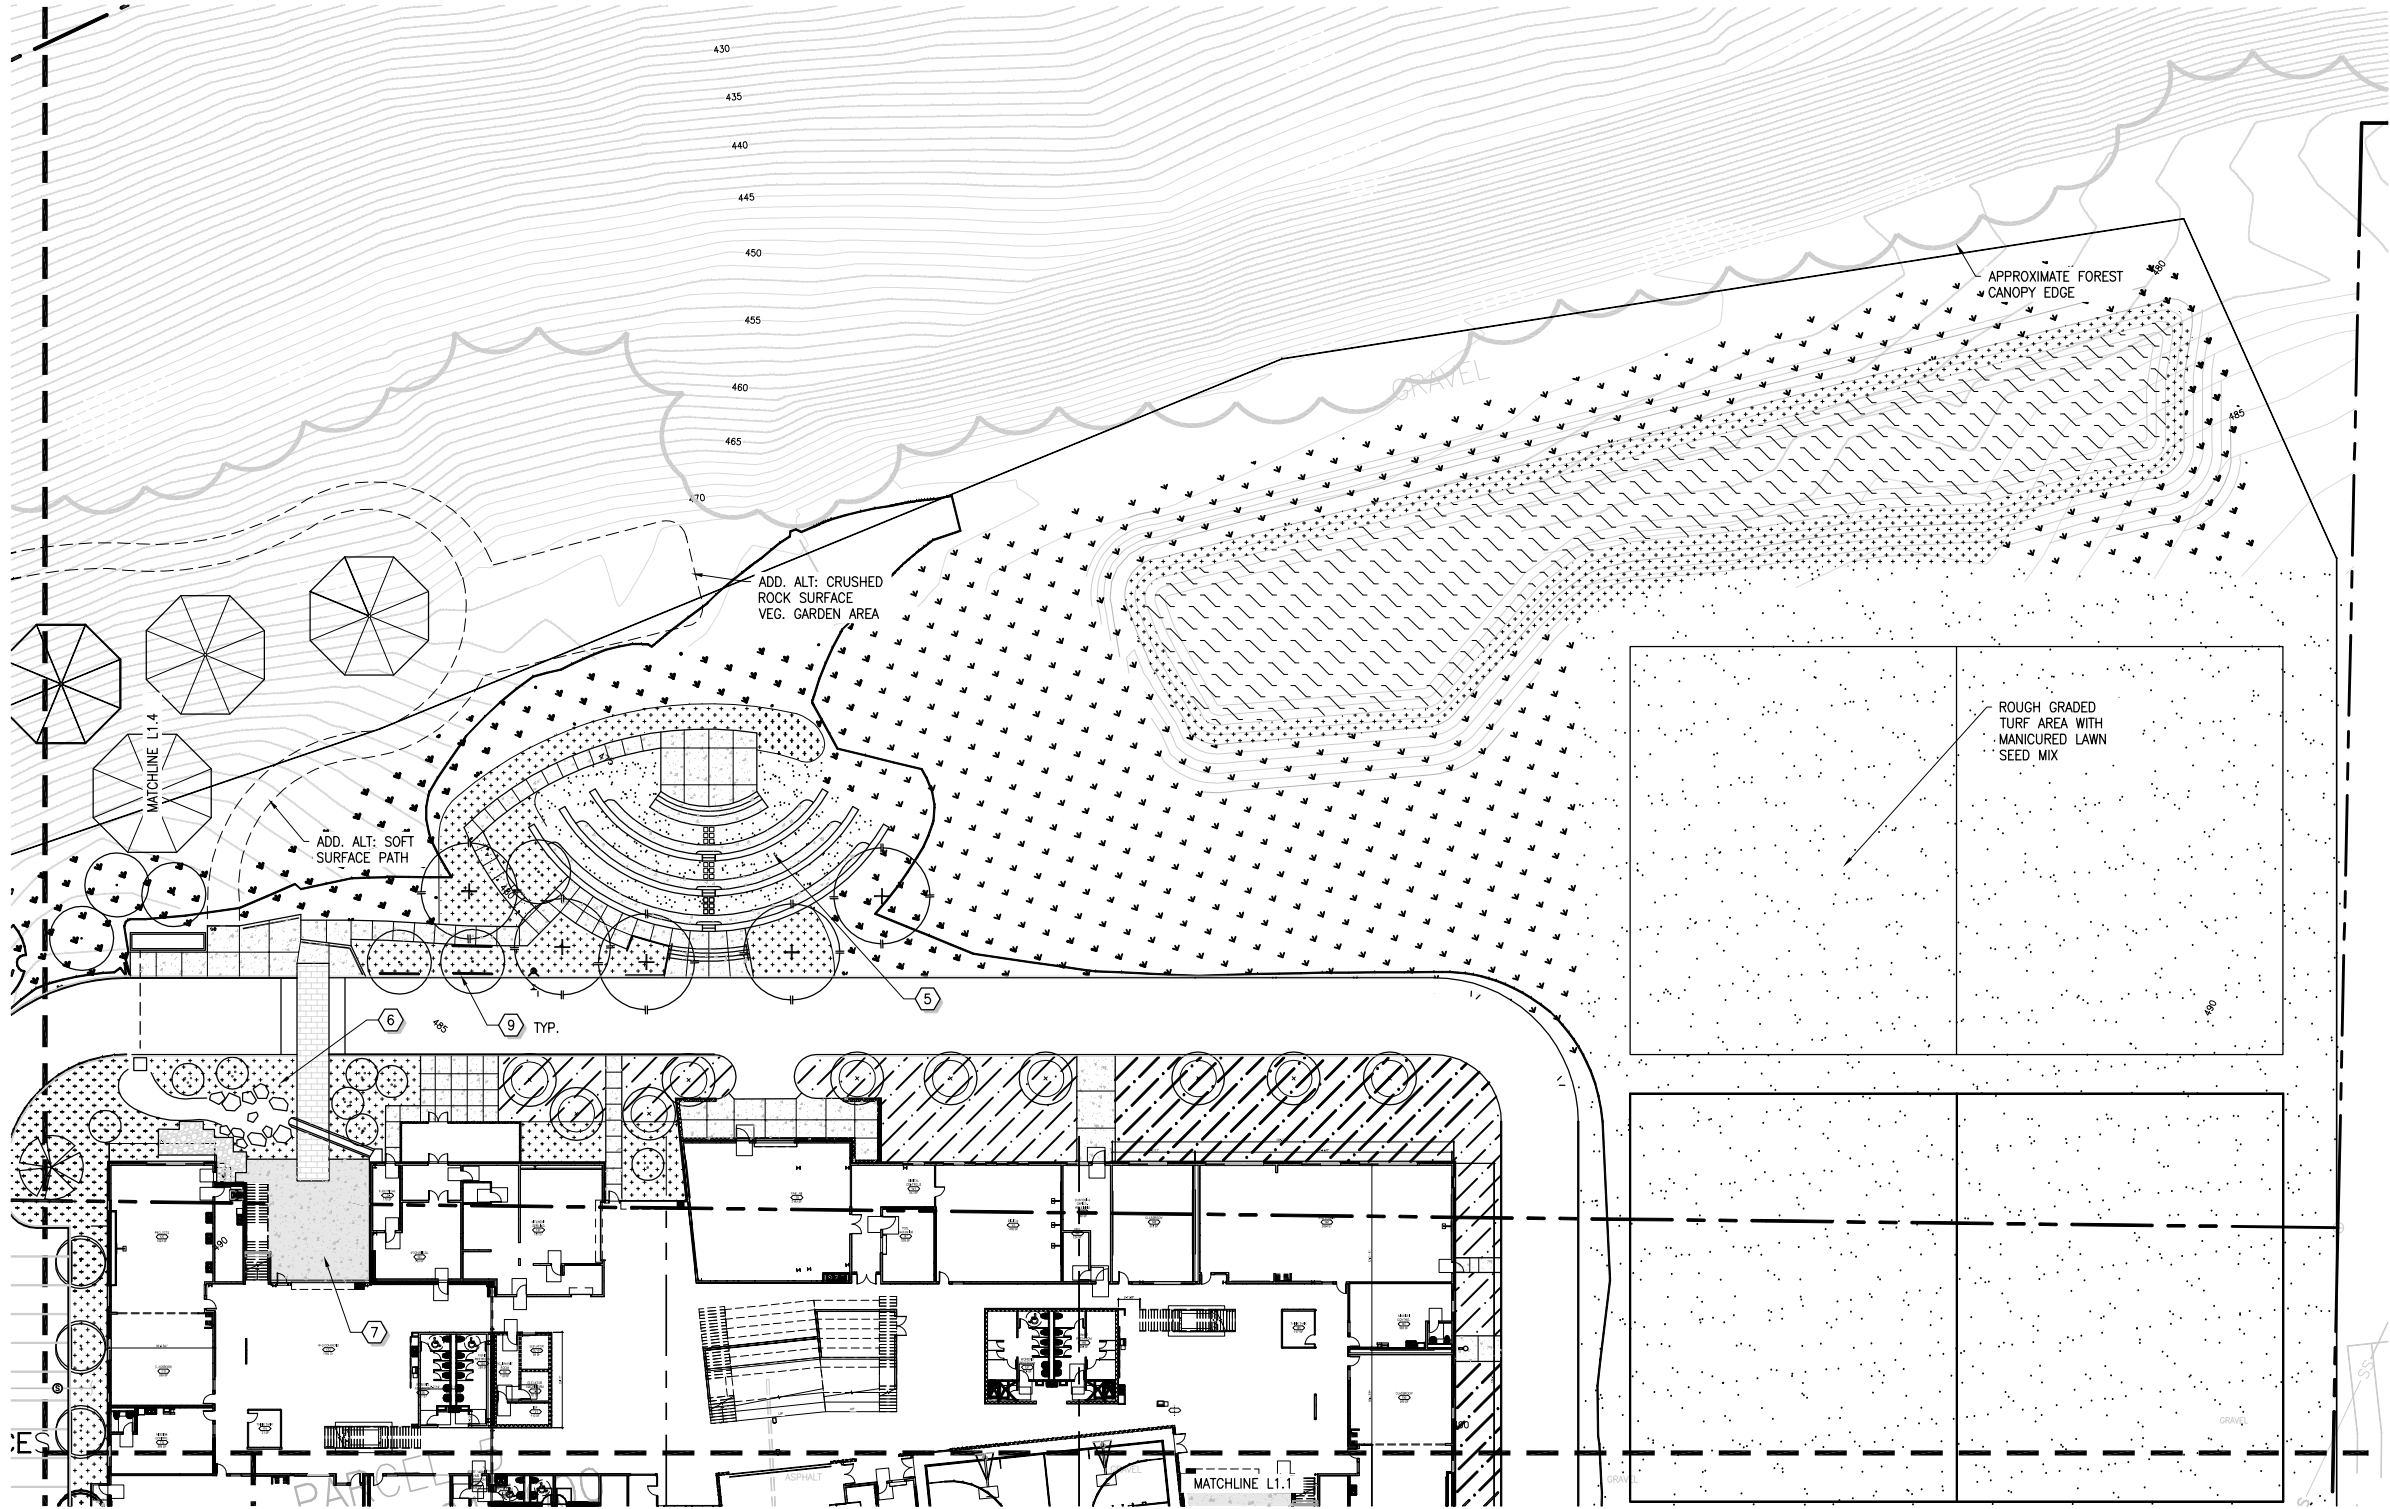

GENERAL NOTES


1. ALL LANDSCAPED AREAS TO BE WATERED BY A FULLY AUTOMATIC UNDERGROUND IRRIGATION SYSTEM.
2. PLANT MATERIAL LEGEND: SEE SHEET L1.4
3. LANDSCAPE INSTALLATION NOTES AND DETAILS: SEE SHEET L4.1 TO L4.8

CONSTRUCTION NOTES



- 1 ENTRY COMMONS AREA. SEE SHEET L3.1
- 2 HARD SURFACE PLAYGROUND AREA. SEE SHEET L3.3
- 3 PEDESTRIAN CROSSING AREA. SEE SHEET L3.1
- 4 BUS LOADING AREA. SEE SHEET L3.1
- 5 AMPHITHEATER AREA. SEE SHEET L3.2
- 6 STORMWATER GARDEN AREA. SEE SHEET L3.2
- 7 OUTDOOR LEARNING AREA. SEE SHEET L3.2
- 8 OUTDOOR LEARNING AREA. SEE SHEET L3.1
- 9 INSTALL 12 LF ROOT BARRIER WHERE INDICATED. SEE SHEET L4.1
- 10 PEDESTRIAN CROSSING AREA AT MIDDLE SCHOOL. SEE SHEET L3.3
- 11 STORM POND OVERLOOK WITH RAILING. SEE SHEET L3.3

LEGEND

- EXISTING EVERGREEN TREE TO REMAIN
- EXISTING DECIDUOUS TREE TO REMAIN

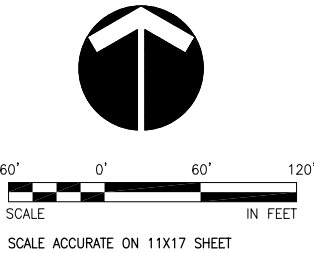

HanmiGlobal Partner
700 Washington St. Ste 401
Vancouver, WA 98660
Phone: (360) 737-9813
Fax: (360) 737-9851
www.otak.com

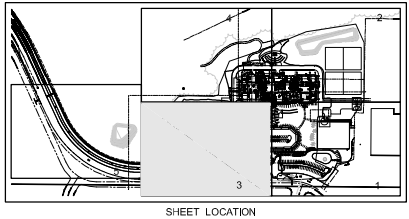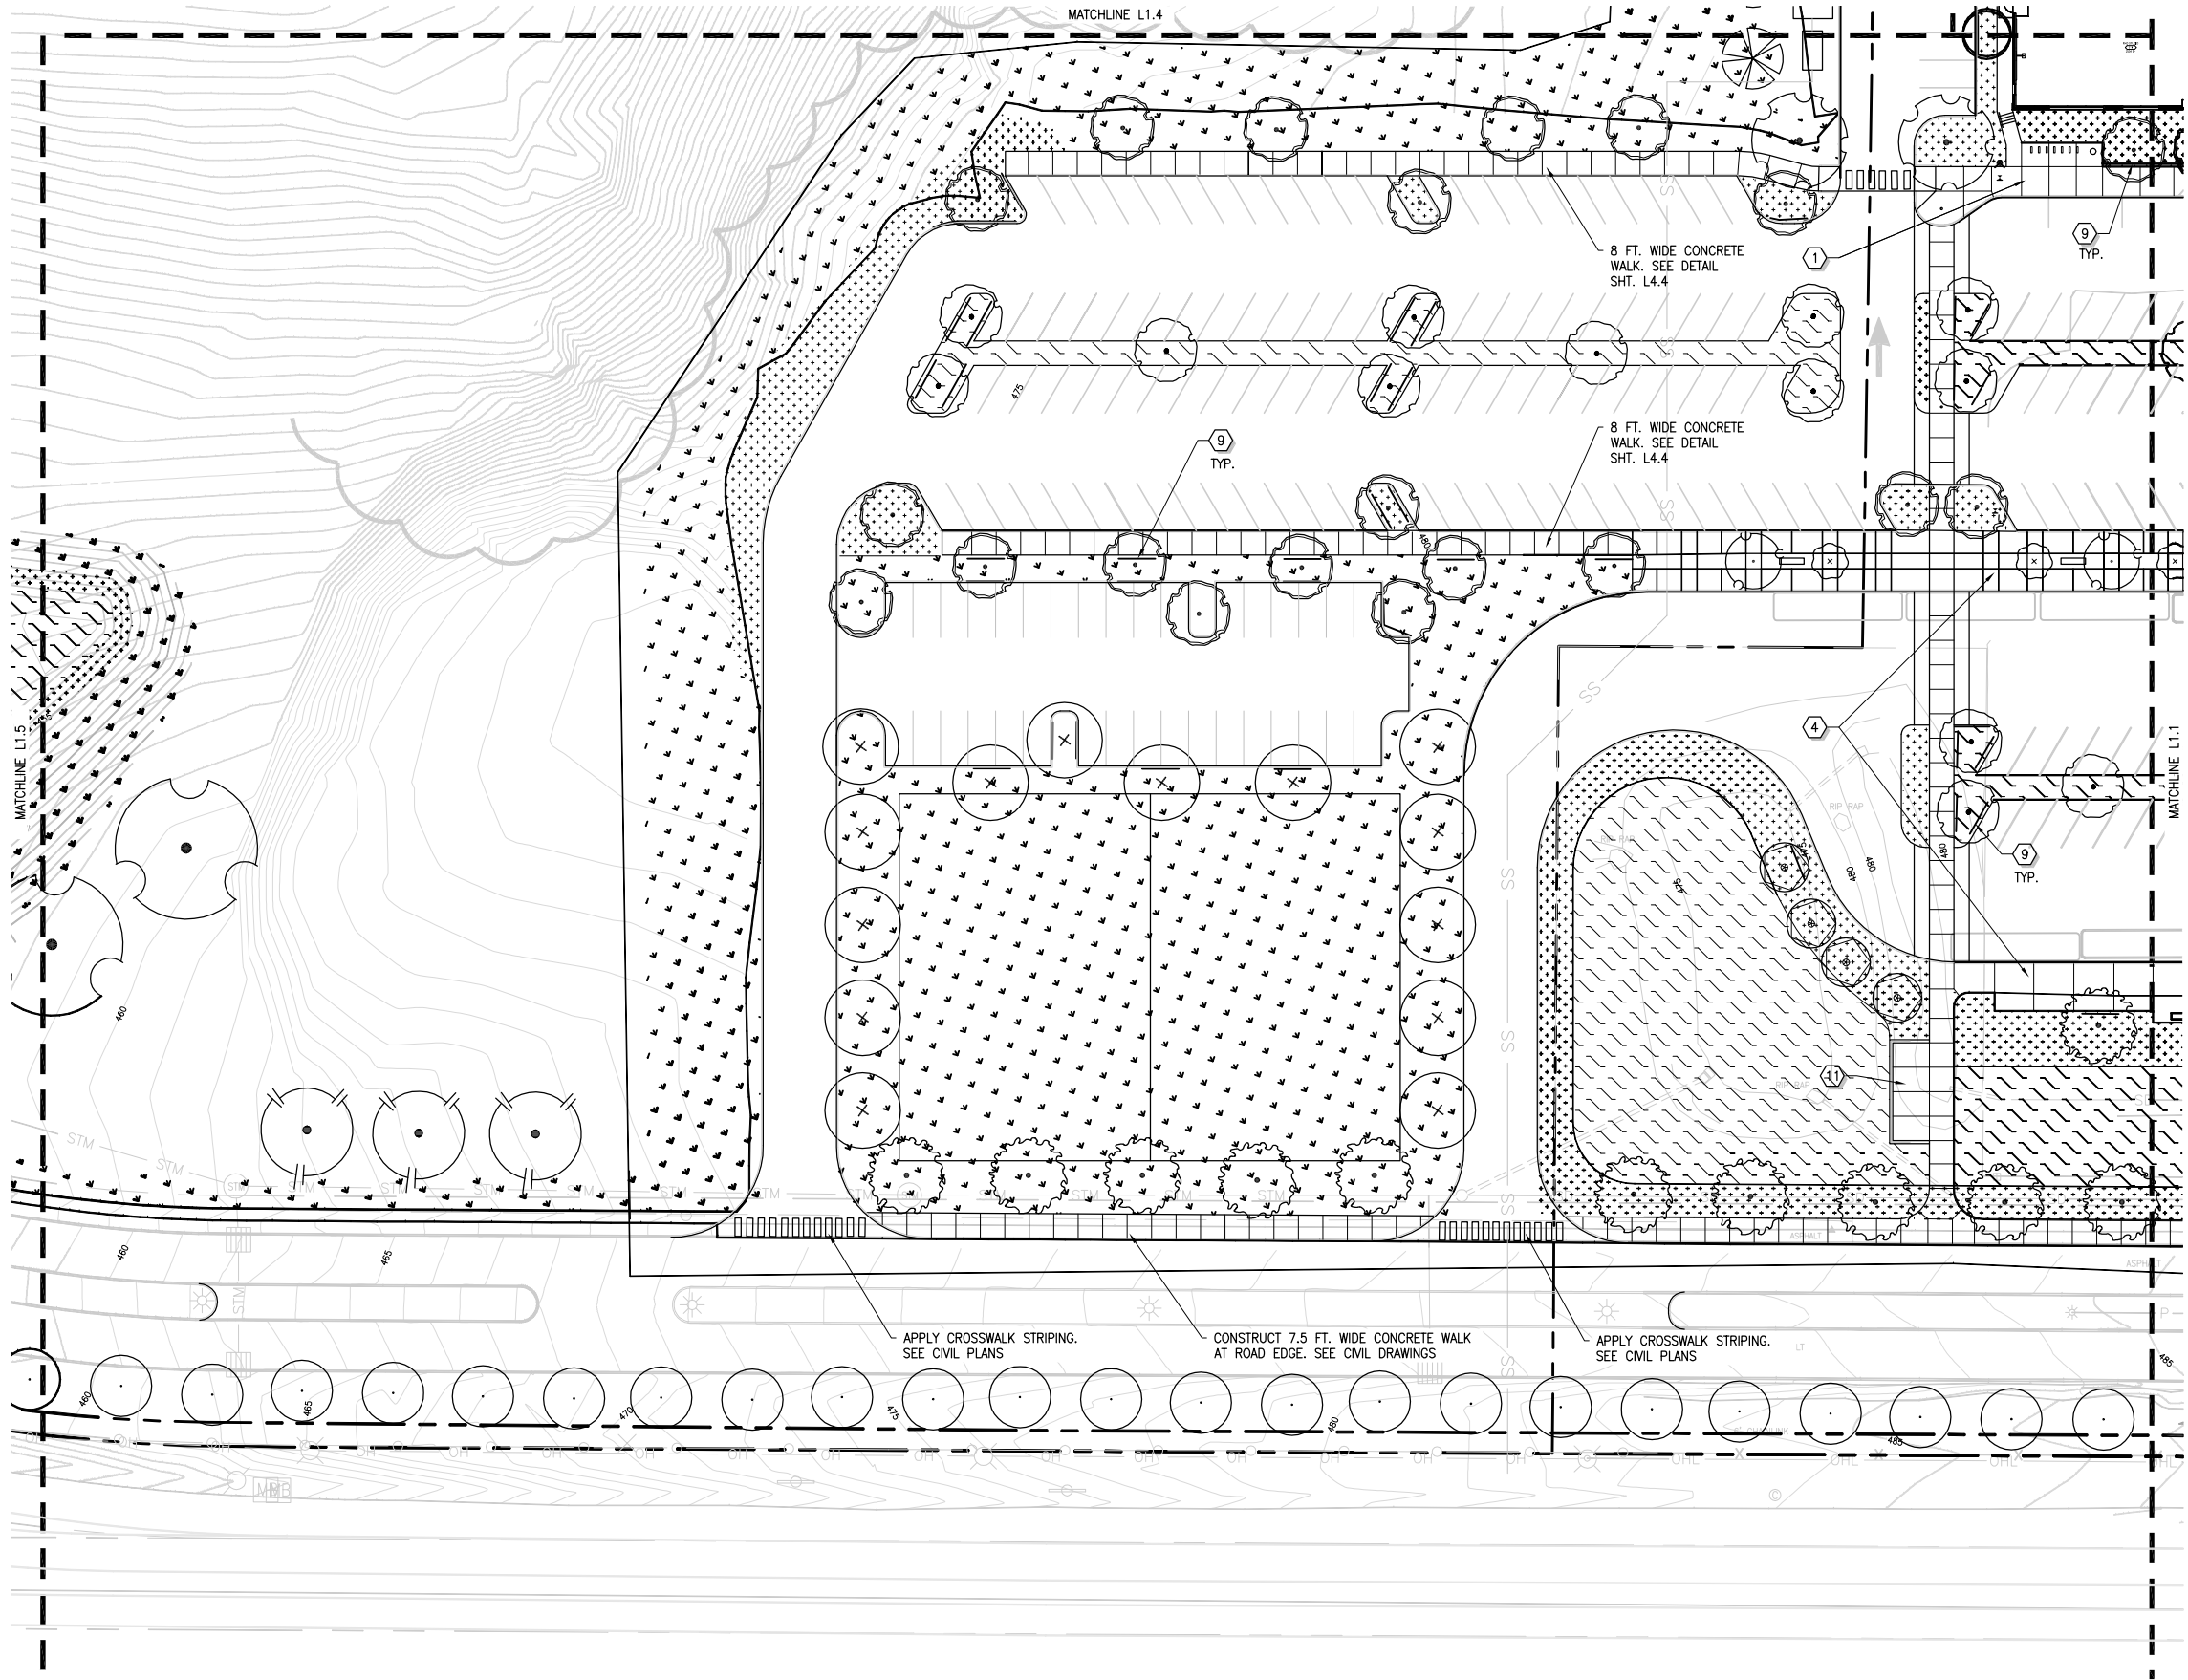

GENERAL NOTES


1. ALL LANDSCAPED AREAS TO BE WATERED BY A FULLY AUTOMATIC UNDERGROUND IRRIGATION SYSTEM.
2. PLANT MATERIAL LEGEND: SEE SHEET L1.4
3. LANDSCAPE INSTALLATION NOTES AND DETAILS: SEE SHEET L4.1 TO L4.8


CONSTRUCTION NOTES

1. ENTRY COMMONS AREA. SEE SHEET L3.1
2. HARD SURFACE PLAYGROUND AREA. SEE SHEET L3.3
3. PEDESTRIAN CROSSING AREA. SEE SHEET L3.1
4. BUS LOADING AREA. SEE SHEET L3.1
5. AMPHITHEATER AREA. SEE SHEET L3.2
6. STORMWATER GARDEN AREA. SEE SHEET L3.2
7. OUTDOOR LEARNING AREA. SEE SHEET L3.2
8. OUTDOOR LEARNING AREA. SEE SHEET L3.1
9. INSTALL 12 LF ROOT BARRIER WHERE INDICATED. SEE SHEET L4.1
10. PEDESTRIAN CROSSING AREA AT MIDDLE SCHOOL. SEE SHEET L3.3
11. STORM POND OVERLOOK WITH RAILING. SEE SHEET L3.3

LEGEND

- EXISTING EVERGREEN TREE TO REMAIN
- EXISTING DECIDUOUS TREE TO REMAIN

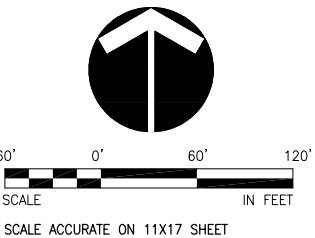

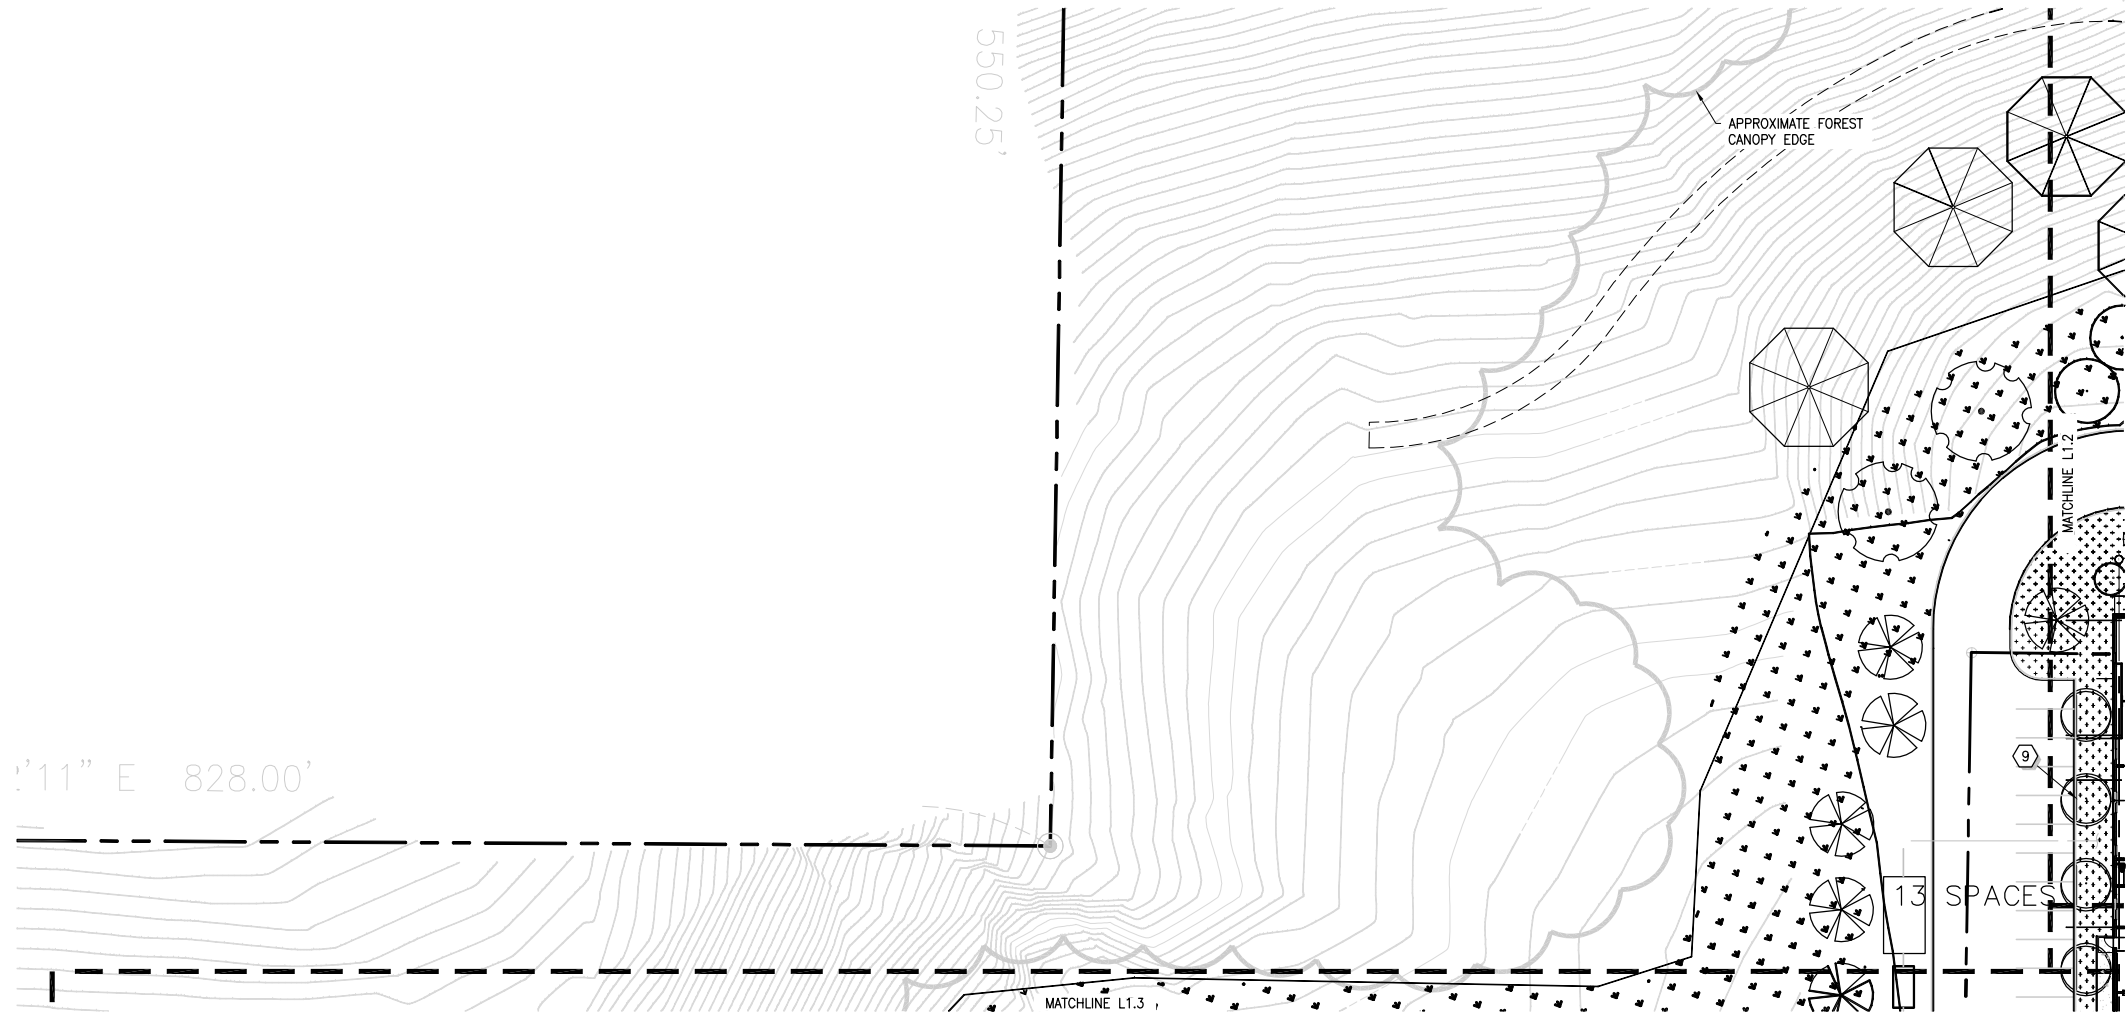


PLANTING LEGEND			
TREES			
SYMBOL	QUANTITY	COMMON NAME / Botanical name	Size and Description
	1	VINE MAPLE /	
	1	Acer circinatum, Multi-stemmed., B&B or 5 Gal cont.	
	1	PAPERBARK MAPLE /	
	1	Acer griseum, 2" CAL., B&B* or container	
	1	BIG LEAF MAPLE /	
	1	Acer macrophyllum, 1 1/2" Cal., B&B*	
	1	RED SUNSET MAPLE /	
	1	Acer rubrum 'Franksred'; 1 1/2" Cal., B&B	
	1	KARPICK RED MAPLE /	
	1	Acer rubrum 'Karpick', 2" CAL., B&B*	
	1	UMBRELLA CATALPA /	
	1	Catalpa bignonioides 'Nano', 2" CAL., B&B or container	
	1	NORTHERN CATALPA /	
	1	Catalpa speciosa, 2" CAL., B&B* or container	
	1	KATSURA /	
	1	Cercidiphyllum japonicum, 1 1/2" Cal., B&B	
	1	EASTERN REDBUD /	
	1	Cercis canadensis , 1" Cal., B&B	
	1	YELLOWWOOD /	
	1	CLADRATIS KENTUCKEA, 1 1/2" Cal., B&B	
	1	JUNE SNOW DOGWOOD /	
	1	Cornus controversa 'June Snow', 2" Cal., B&B	
	1	TULIP TREE /	
	1	Liriodendron tulipifera	
	1	2" CAL., B&B*	
	1	DAWN REDWOOD /	
	1	Metasequoia glyptostroboidesM 2" CAL., B&B* or container	
	1	BLACK TUPELO /	
	1	Nyssa sylvatica	
	1	2" CAL., B&B or container	
	1	YOSHINO CHERRY /	
	1	Prunus x yedoensis 'Akebono' 1 1/2" Cal., B&B	
	1	REDSPIRE CALLERY PEAR /	
	1	Pyrus calleryana 'Redspire': 2" CAL., B&B*	
	1	SCARLET OAK /	
	1	Quercus coccinea	
	1	2" CAL., B&B* or container	
	1	OREGON WHITE OAK /	
	1	Quercus garryana	
	1	1 3/4" Cal., B&B	
	1	NATIONAL KOUSA DOGWOOD /	
	1	Cornus kousa 'National', 1 1/2" Cal., B&B	

SEEDING LAWN AND OTHER PLANTED AREAS		
SYMBOL	QTY	DESCRIPTION
	110,940 SF	SEEDING LAWN, MANICURED, MIX FOR SUN
	10,000 SF	SEEDING LAWN-MANICURED, MIX FOR SHADE
	120,507 SF	SEEDING LAWN-MEADOW MIX
	18,777 SF	SHRUB BEDS
	71,585 SF	STORMWATER FACILITY PLANTING

SHRUB LIST	
COMMON NAME /	Botanical name:
DWARF BURNING BUSH /	Euonymus alatus 'Compacta'
LILY TURF	Liriope gigantea (Ophiopogon japonicus)
TALL OREGON GRAPE /	Mahonia aquifolium
GULF STREAM NANDINA /	Nandina domestica 'Gulf Stream'
DAFFODIL (GROUP OF 3 BULBS 6" O.C.)	Narcissus spp.
WESTERN SWORDFERN /	Polystichum munitum
OTTO LUYKEN ENGLISH LAUREL /	Prunus laurocerasus 'Otto Luyken'
INDIAN PRINCESS RHAPHIOLEPIS /	Rhaphiolepis indica 'Indian Princess'
FLOWER CARPET ROSE /	Rosa 'FLOWER CARPET SCARLET SUPREME'
LEMON PRINCESS SPIREA	Spiraea japonica 'Lemon Princess'
DAVID VIBURNUM /	Viburnum davidii

OTHER		
SYMBOL	QUANTITY	DESCRIPTION
	1	CONCRETE WALK
	1	STAMPED CONCRETE
	1	OUTDOOR LEARNING AREA SURFACE

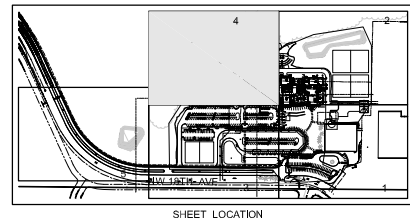



GENERAL NOTES



1. ALL LANDSCAPED AREAS TO BE WATERED BY A FULLY AUTOMATIC UNDERGROUND IRRIGATION SYSTEM.
2. PLANT MATERIAL LEGEND: SEE SHEET L1.4
3. LANDSCAPE INSTALLATION NOTES AND DETAILS: SEE SHEET L4.1 TO L4.8

CONSTRUCTION NOTES

1. ENTRY COMMONS AREA. SEE SHEET L3.1
2. HARD SURFACE PLAYGROUND AREA. SEE SHEET L3.3
3. PEDESTRIAN CROSSING AREA. SEE SHEET L3.1
4. BUS LOADING AREA. SEE SHEET L3.1
5. AMPHITHEATER AREA. SEE SHEET L3.2
6. STORMWATER GARDEN AREA. SEE SHEET L3.2
7. OUTDOOR LEARNING AREA. SEE SHEET L3.2
8. OUTDOOR LEARNING AREA. SEE SHEET L3.1
9. INSTALL 12 LF ROOT BARRIER WHERE INDICATED. SEE SHEET L4.1
10. PEDESTRIAN CROSSING AREA AT MIDDLE SCHOOL. SEE SHEET L3.3
11. STORM POND OVERLOOK WITH RAILING. SEE SHEET L3.3

 LEGEND

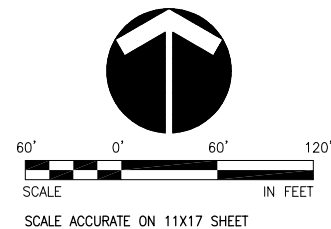

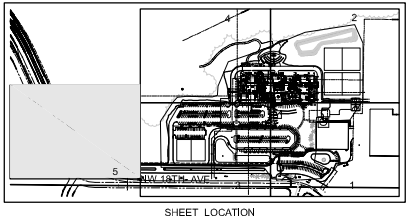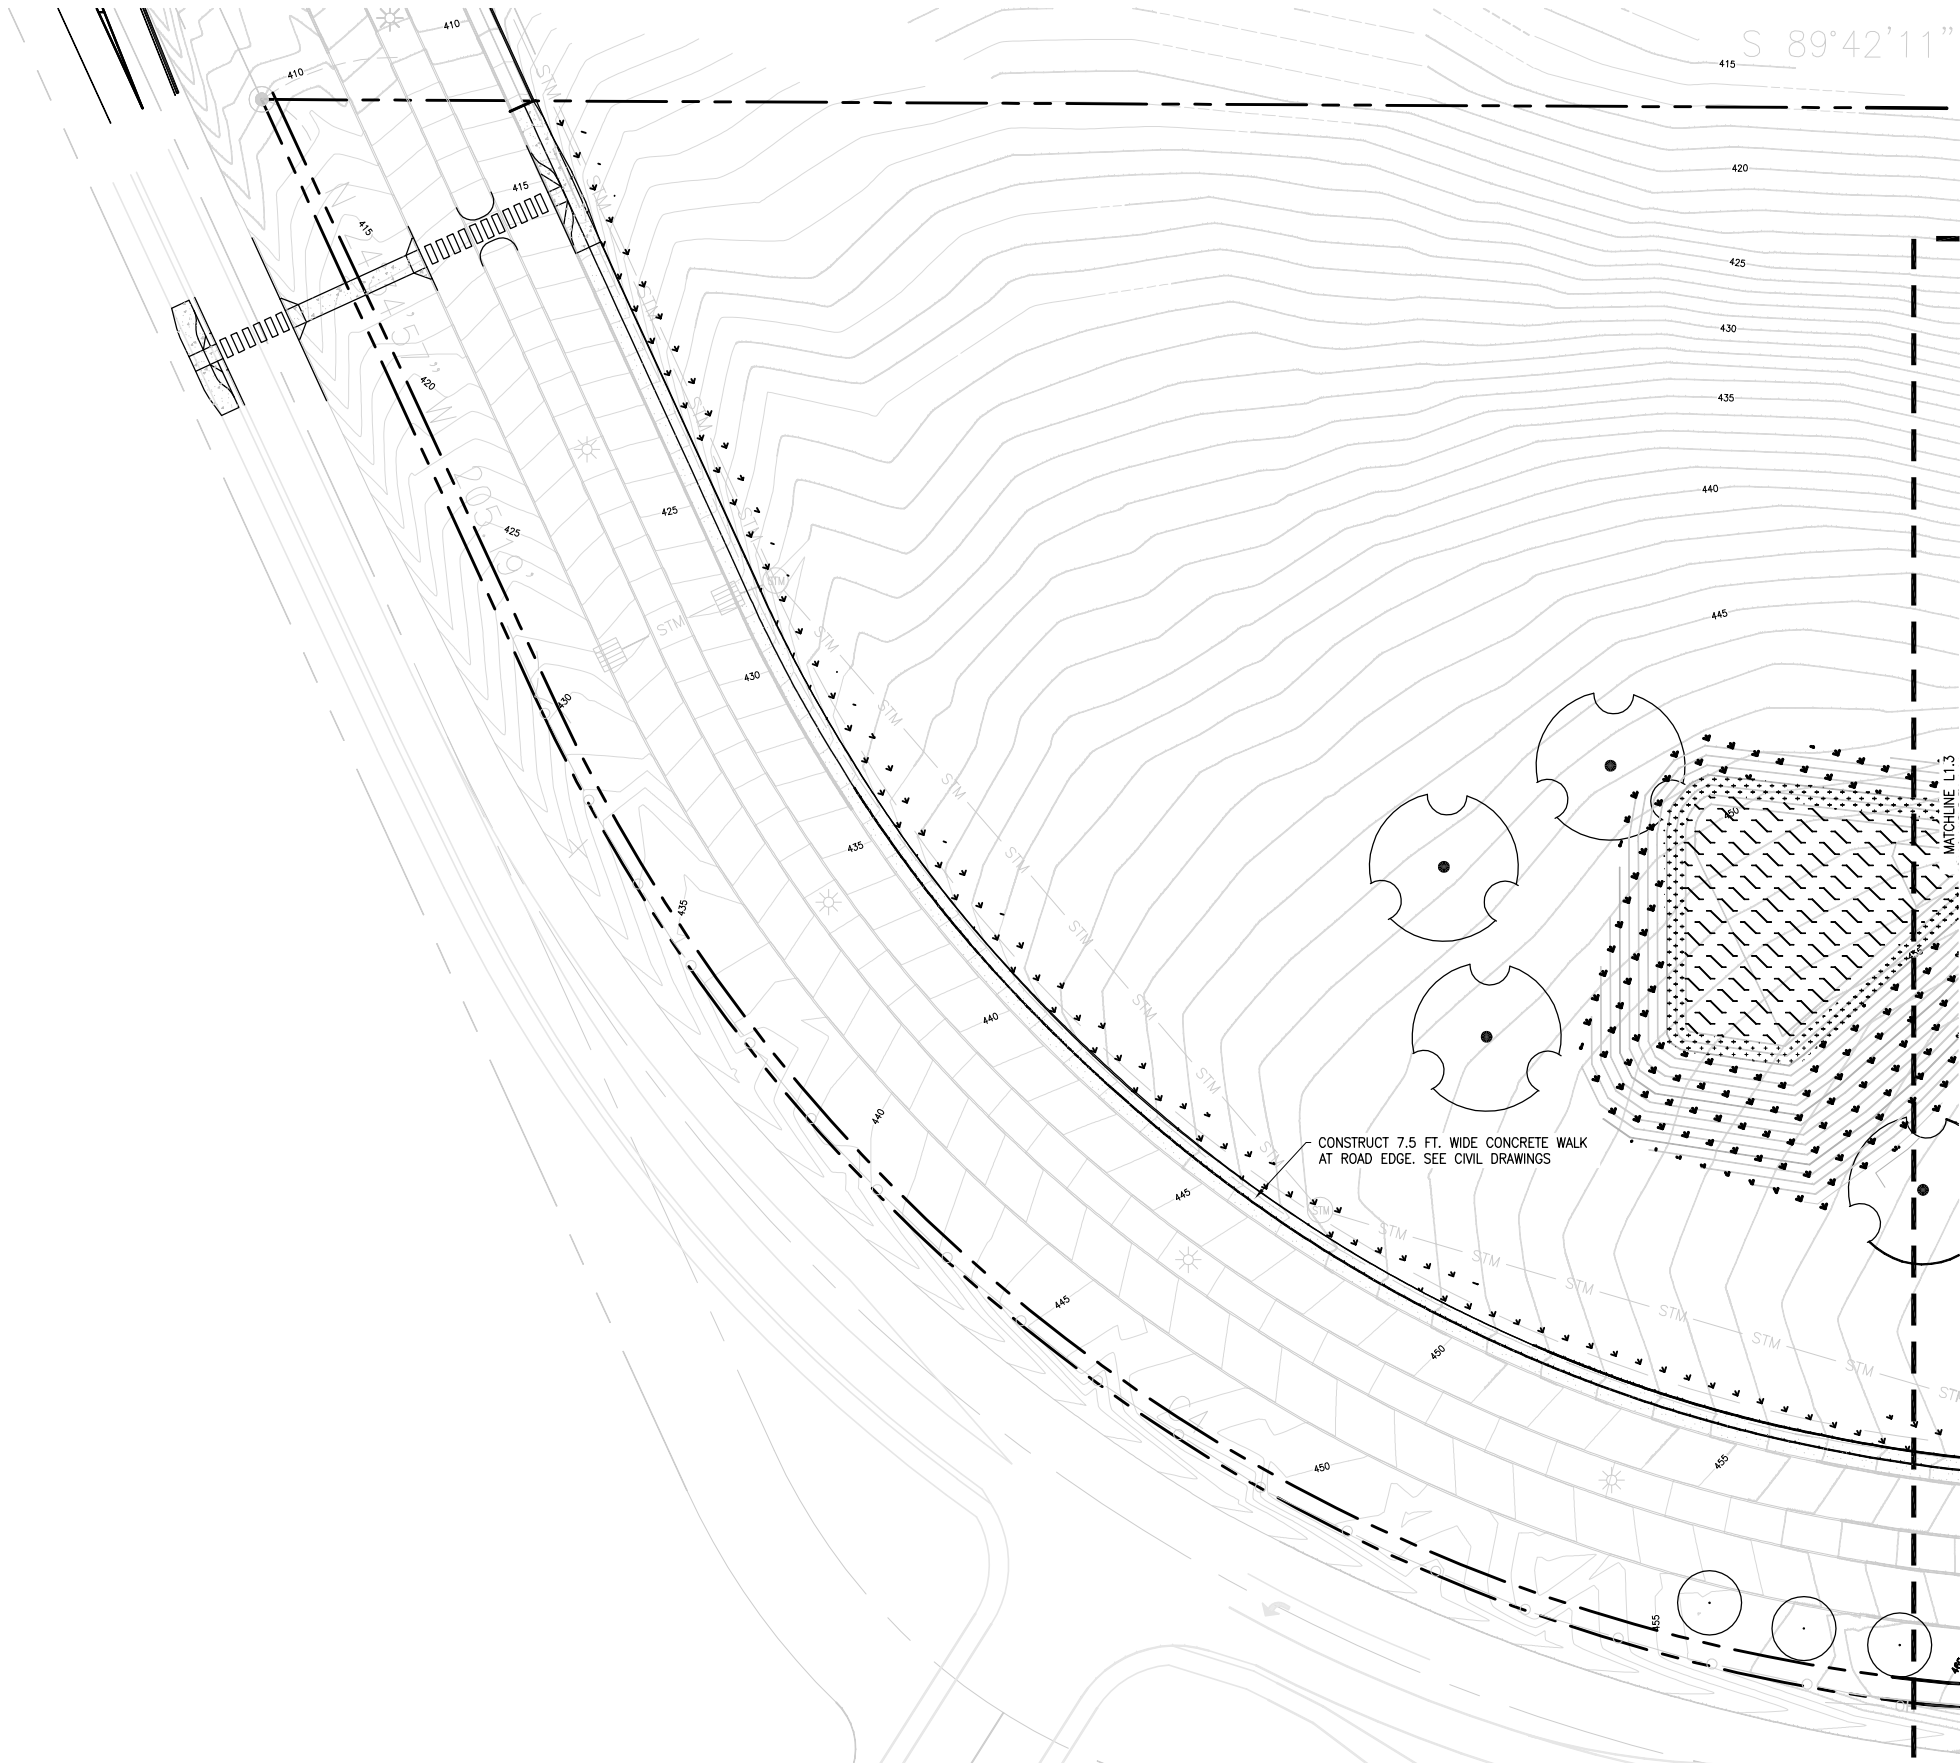

GENERAL NOTES


1. ALL LANDSCAPED AREAS TO BE WATERED BY A FULLY AUTOMATIC UNDERGROUND IRRIGATION SYSTEM.
2. PLANT MATERIAL LEGEND: SEE SHEET L1.4
3. LANDSCAPE INSTALLATION NOTES AND DETAILS: SEE SHEET L4.1 TO L4.8

CONSTRUCTION NOTES

- 1 ENTRY COMMONS AREA. SEE SHEET L3.1
- 2 HARD SURFACE PLAYGROUND AREA. SEE SHEET L3.3
- 3 PEDESTRIAN CROSSING AREA. SEE SHEET L3.1
- 4 BUS LOADING AREA. SEE SHEET L3.1
- 5 AMPHITHEATER AREA. SEE SHEET L3.2
- 6 STORMWATER GARDEN AREA. SEE SHEET L3.2
- 7 OUTDOOR LEARNING AREA. SEE SHEET L3.2
- 8 OUTDOOR LEARNING AREA. SEE SHEET L3.1
- 9 INSTALL 12 LF ROOT BARRIER WHERE INDICATED. SEE SHEET L4.1
- 10 PEDESTRIAN CROSSING AREA AT MIDDLE SCHOOL. SEE SHEET L3.3
- 11 STORM POND OVERLOOK WITH RAILING. SEE SHEET L3.3

LEGEND


- EXISTING EVERGREEN TREE TO REMAIN
- EXISTING DECIDUOUS TREE TO REMAIN

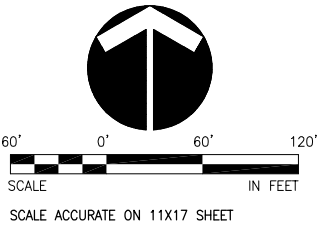




FLOOR PLAN, FIRST LEVEL



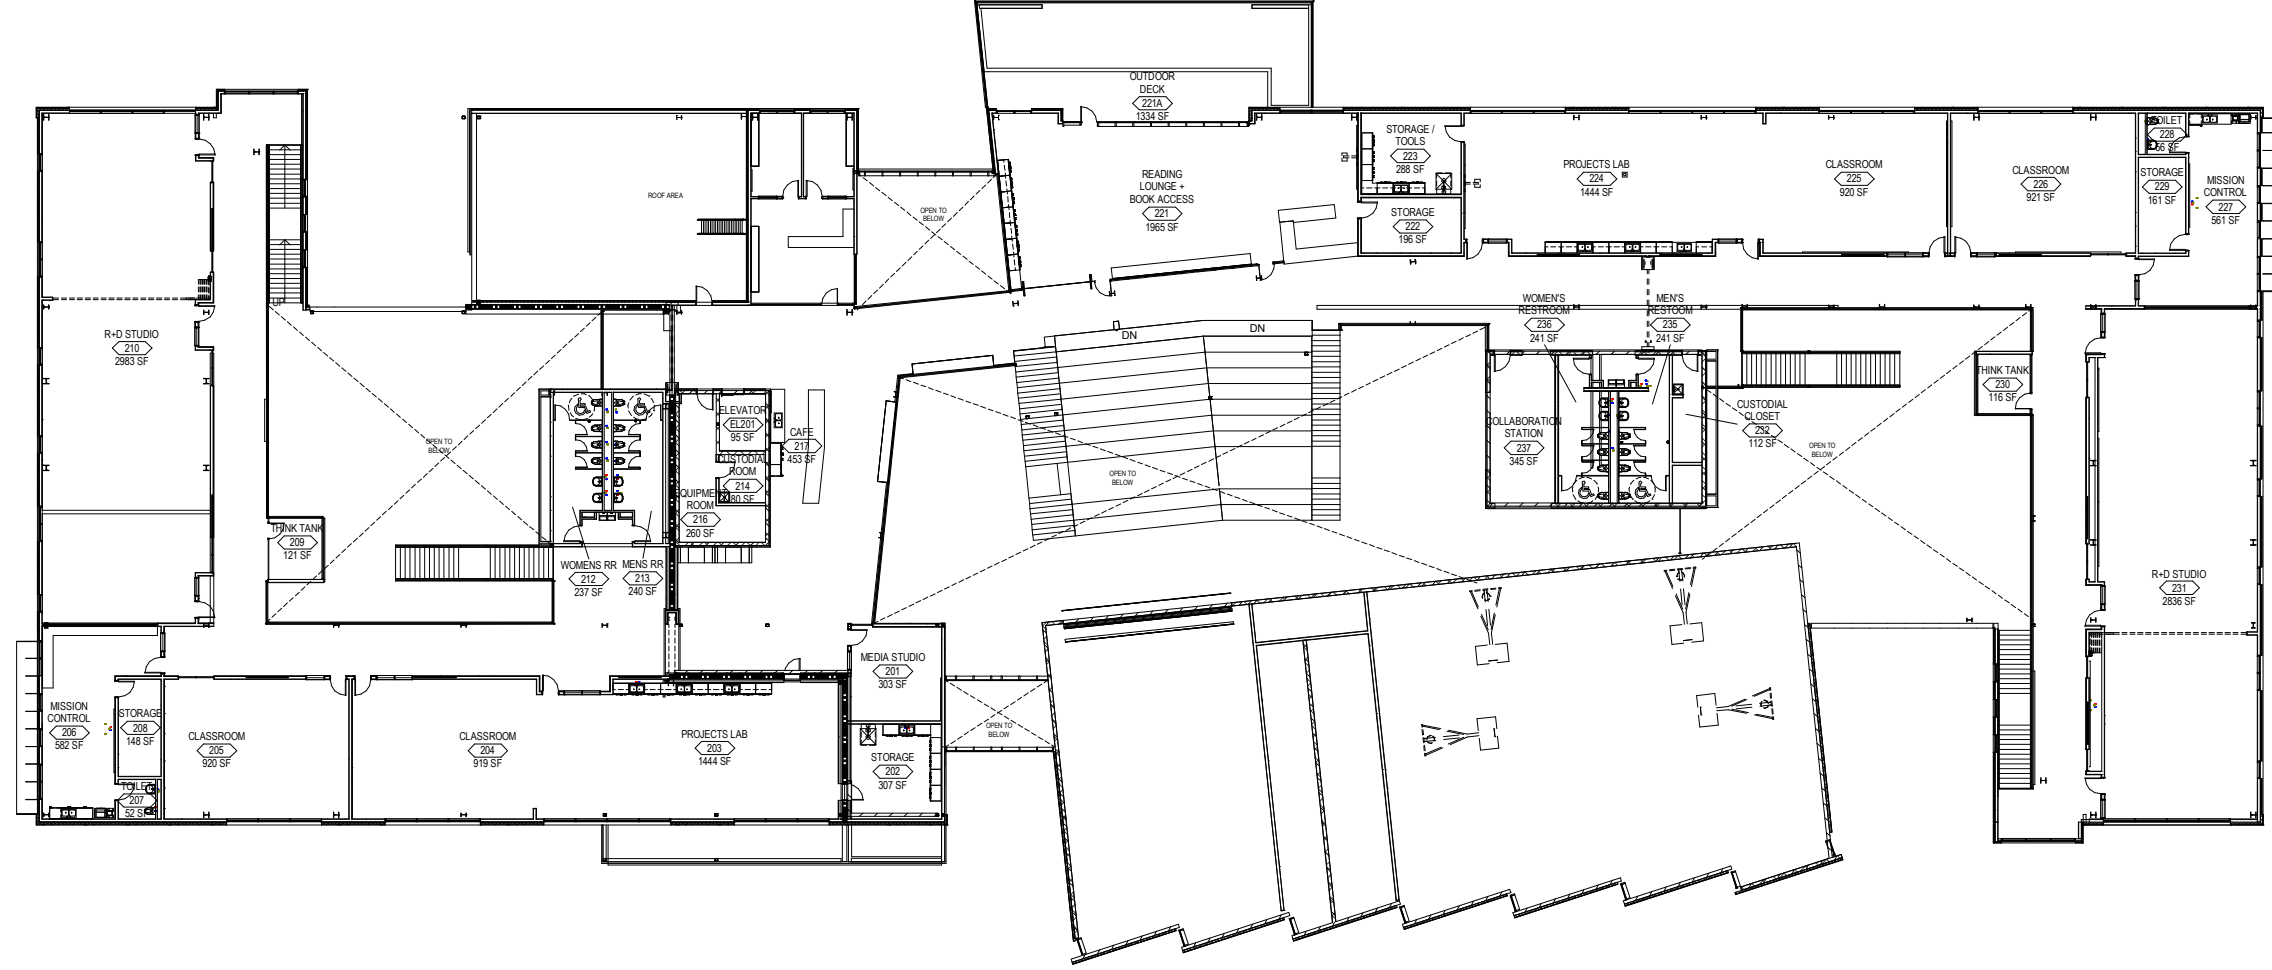


 FLOOR PLAN, SECOND LEVEL

C:\Revit\73-16130_Camas HS_AR Central_2015_fmueller.rvt
1/6/2017 12:31:14 PM

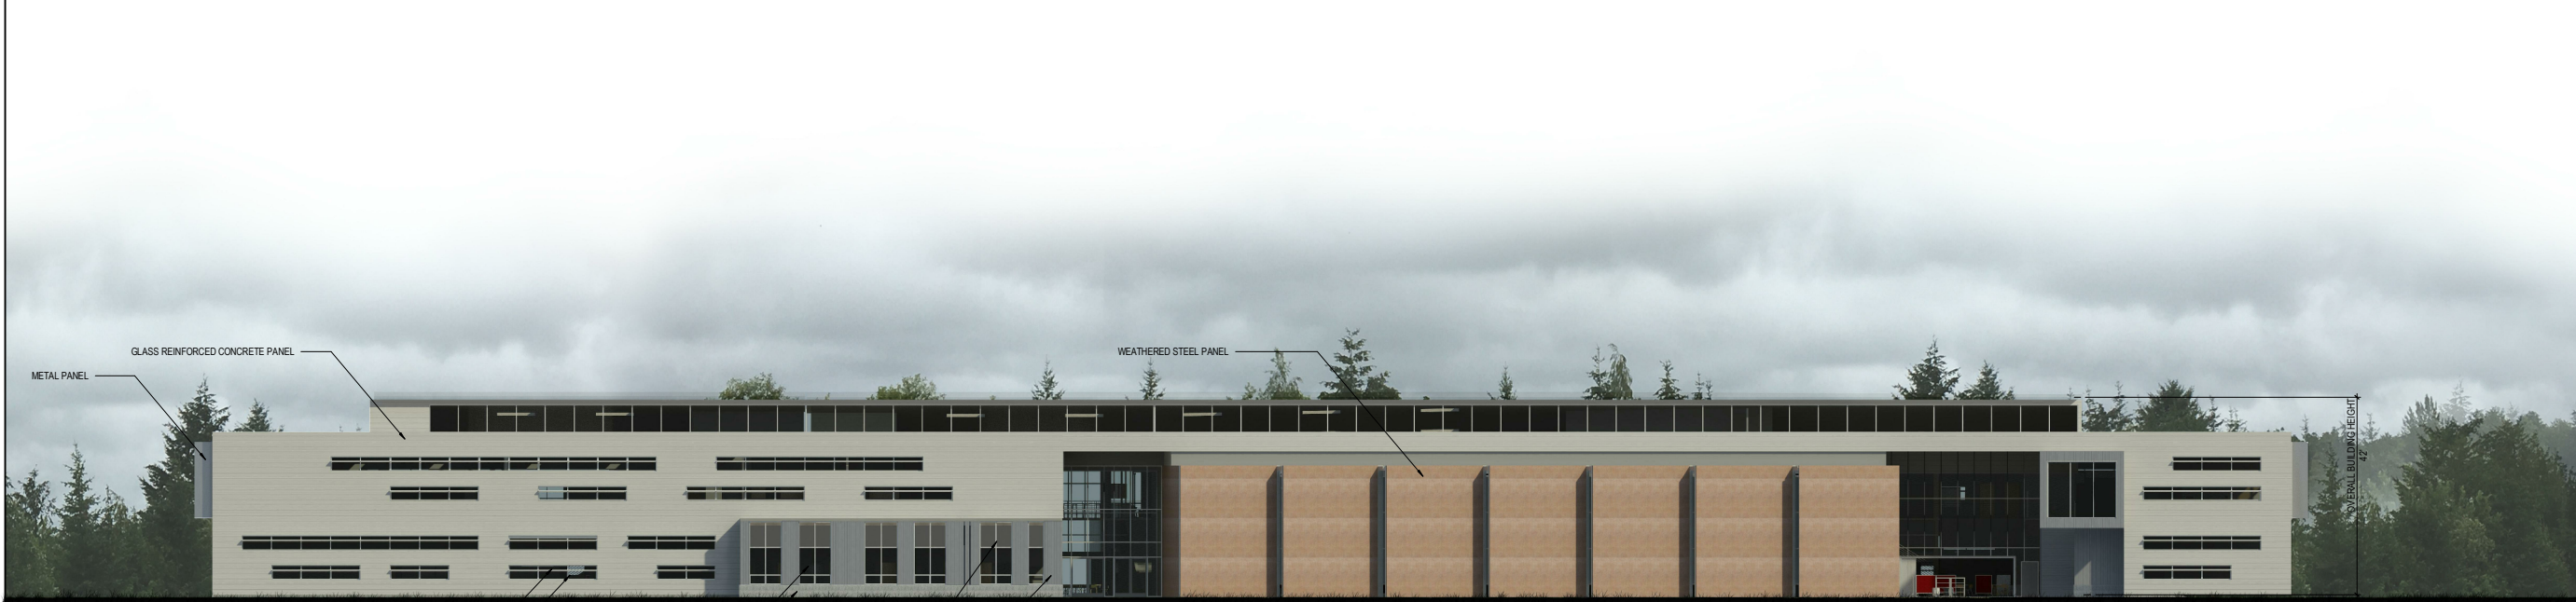

SOUTH ELEVATION
NOT TO SCALE

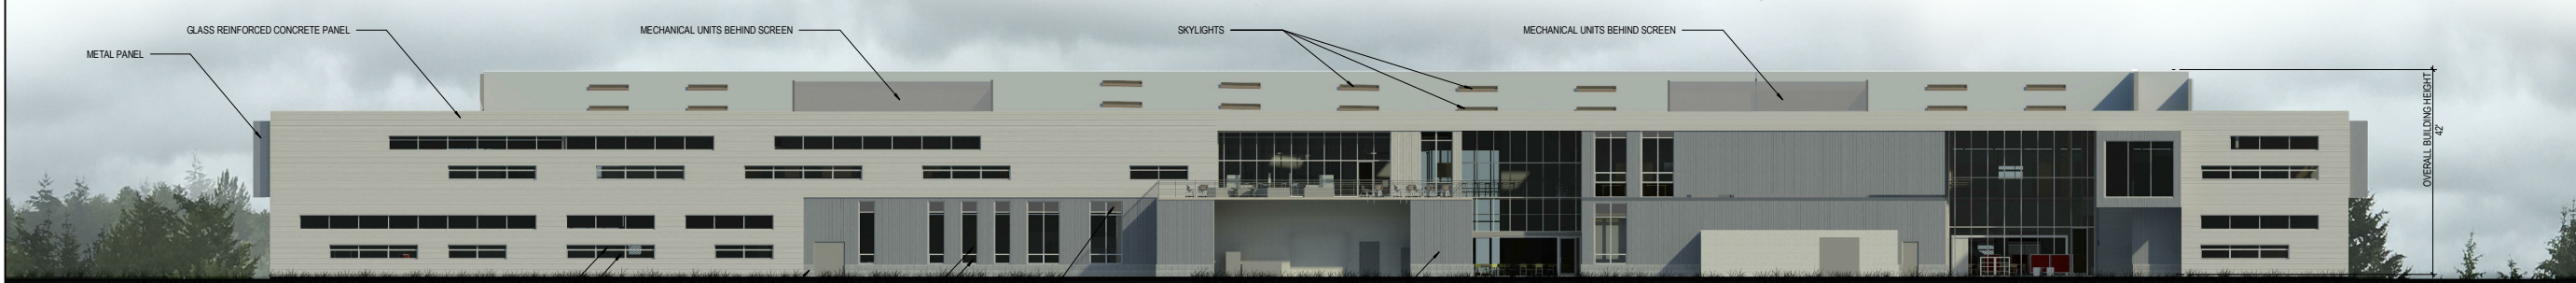

NORTH ELEVATION
NOT TO SCALE

DESIGN REVIEW

EXTERIOR ELEVATIONS
CAMAS PBL HIGH SCHOOL
CAMAS SCHOOL DISTRICT

SD 5.3

73-16130-00
01.06.2017
REVISIONS



EAST ELEVATION
NOT TO SCALE



WEST ELEVATION
NOT TO SCALE

DESIGN REVIEW


EXTERIOR ELEVATIONS
CAMAS PBL HIGH SCHOOL
CAMAS SCHOOL DISTRICT

SD 5.4

73-16130-00
01.06.2017
REVISIONS

SHEET KEYNOTES

- REFER TO ONE-LINE DIAGRAM FOR UTILITY SERVICE RACEWAY.
- 1-4" CONDUIT W/4 1-1/2" INNERDUCTS FOR TELECOM. ONE INNERDUCT FOR 24 STRAND SINGLE MODE FIBER CABLE. PULL STRINGS IN REMAINING 3 INNERDUCT. 1-2" CONDUIT FOR 12 PAIR TELEPHONE CABLE AND 1-2" CONDUIT FOR FUTURE USE.
- FOUR WAY ARECONT VISION CORNER MOUNT CAMERA, AP20175DN SERIES. SELECT AND POSITION LENSES TO PROVIDE OWNER APPROVED FIELD OF VIEW.

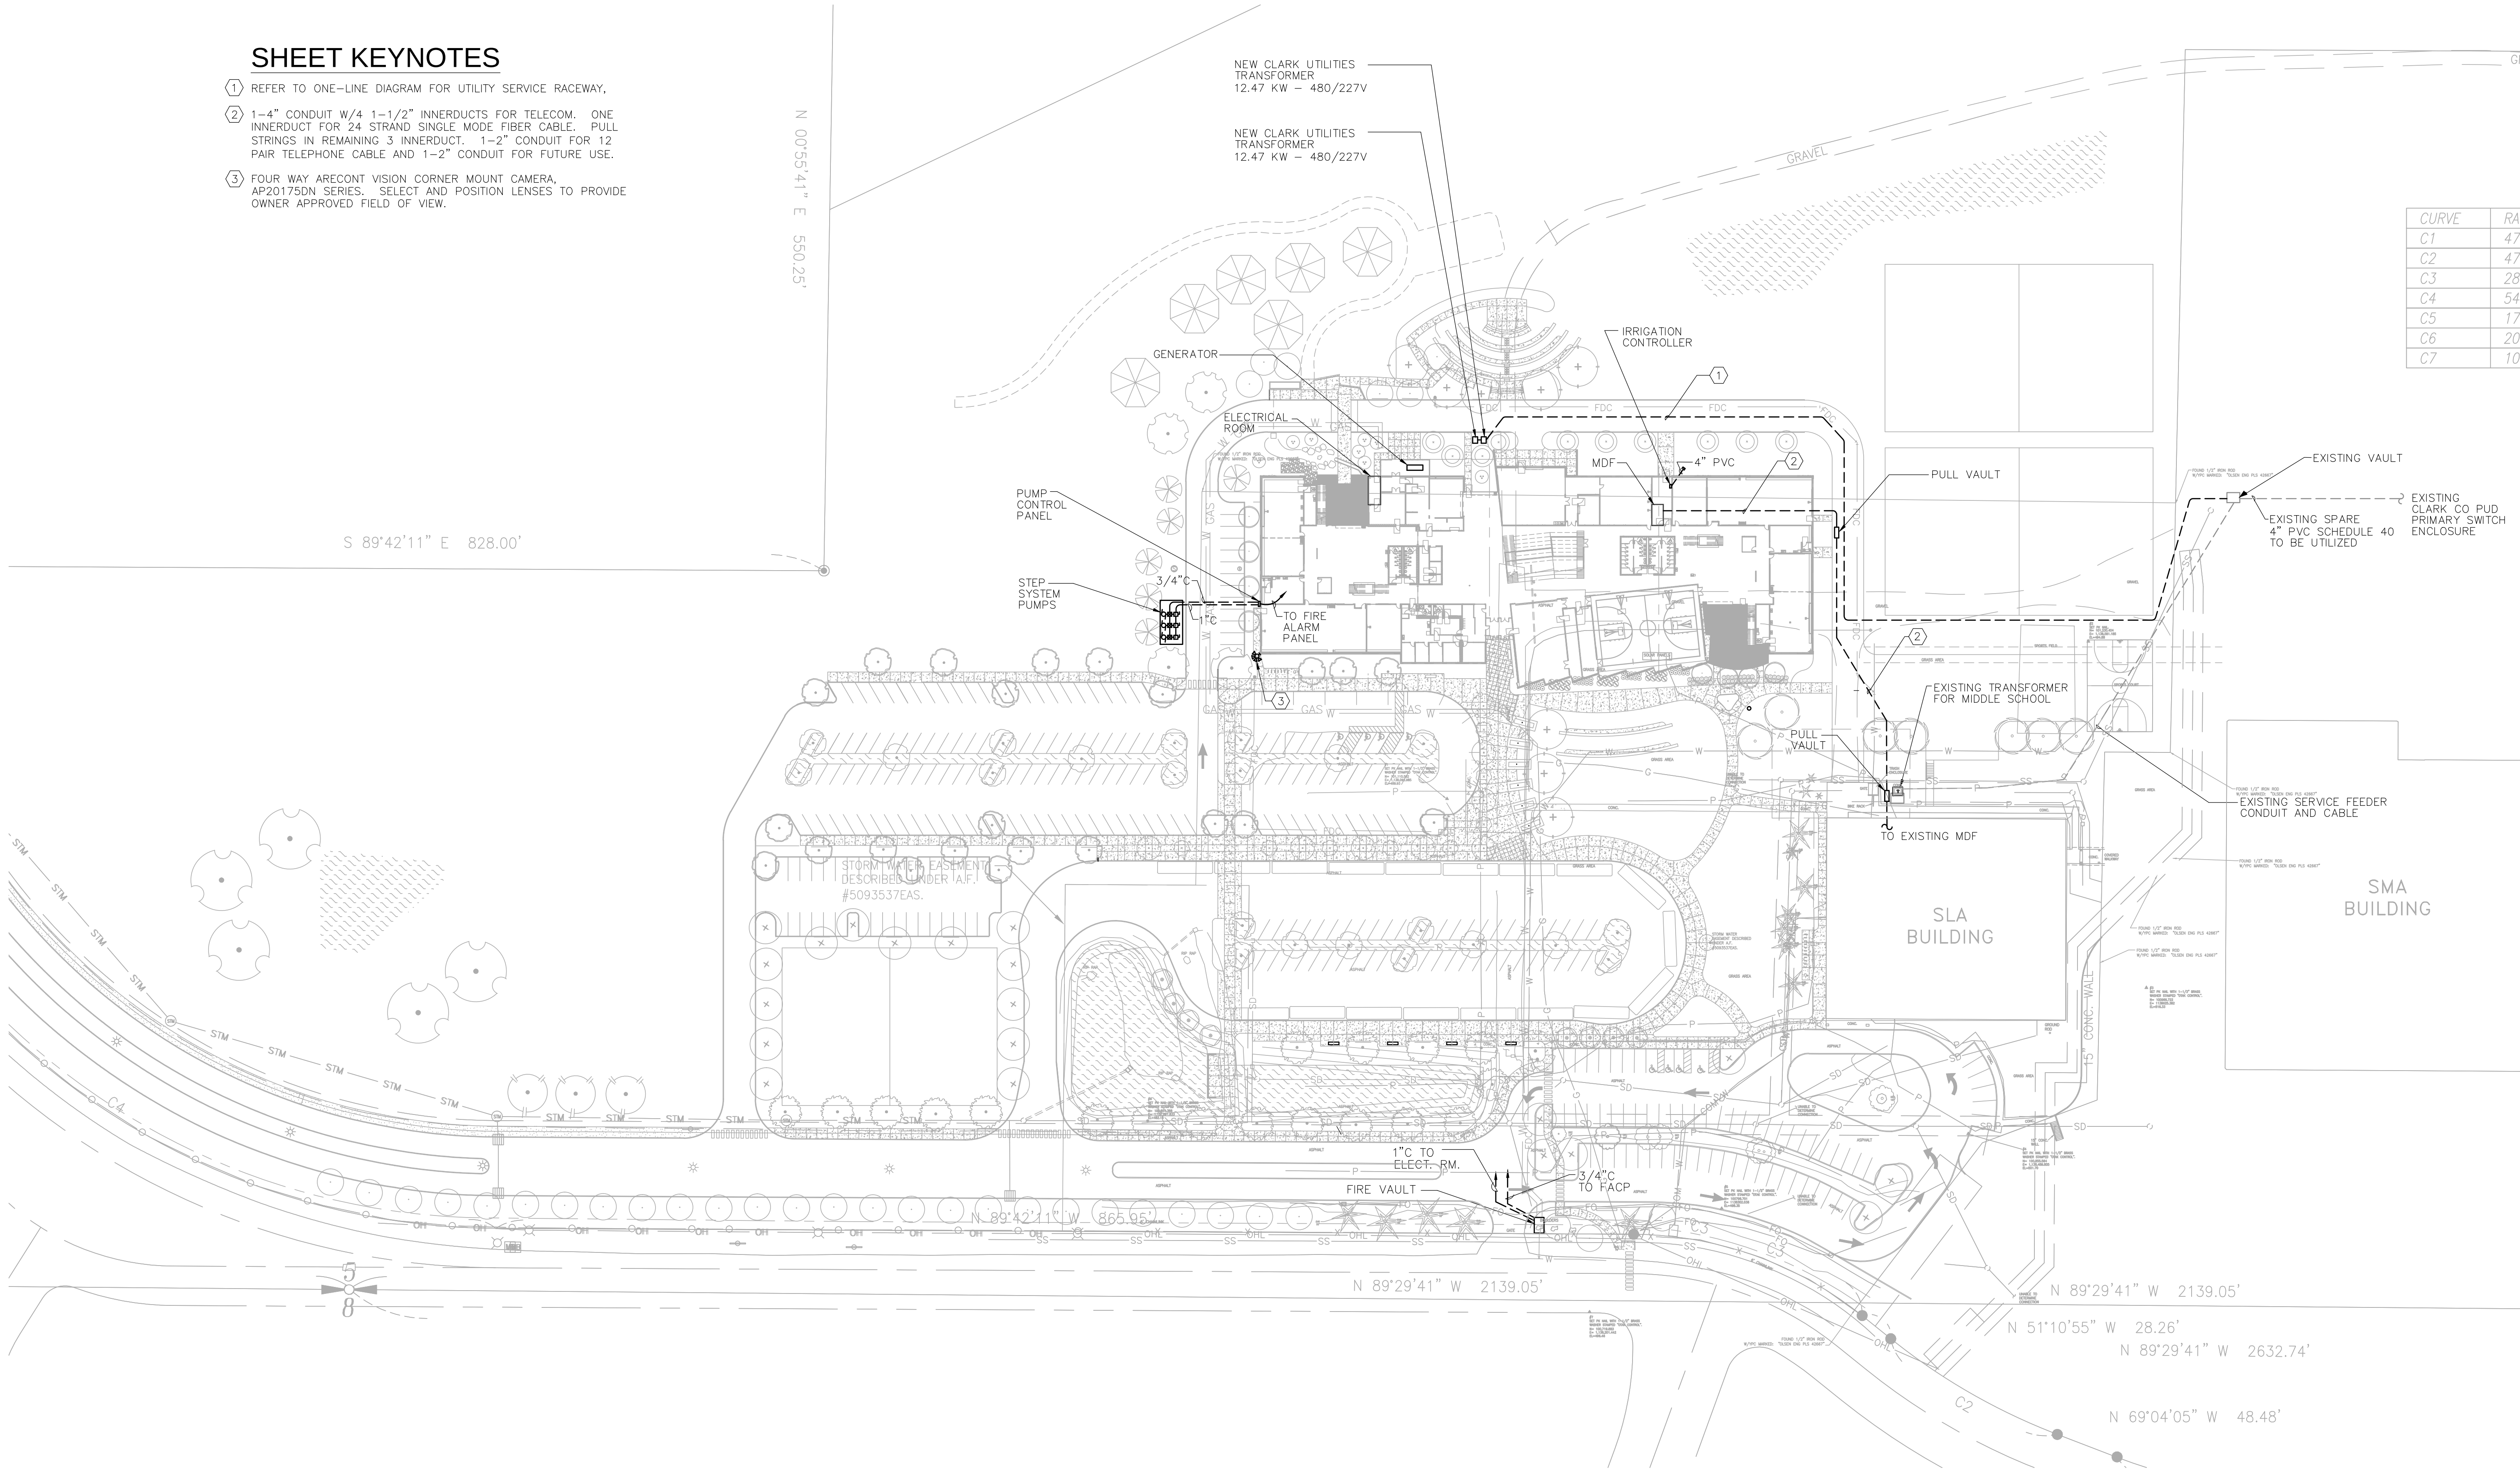

SITE PLAN - ELECTRICAL

SCALE: 1" = 60'-0"

08 DD - PROGRESS
SET

SITE PLAN - ELECTRICAL
CAMAS PBL HIGH SCHOOL
CAMAS SCHOOL DISTRICT

E0.3
73-16130-00
09/23/16
REVISIONS

DLR Group
Architecture Planning Interiors

© 2016, DLR Group Architecture & Planning Inc. an Oregon corporation. ALL RIGHTS RESERVED

1 IF THE AREA BELOW IS ADDED, REVISE THESE TWO LUMINAIRES AS 'SA2'

08 DD - PROGRESS
SET

1/16/17 4:38 PM

TYPE	DESCRIPTION	MANUFACTURER/SERIES	FINISH	MOUNTING	LAMP(S)	VOLTS	DRIVER/BALLAST	VA
SA	POLE MOUNTED LED AREA LUMINAIRE TYPE III DISTRIBUTION, MOUNTED @+25'	LITHONIA "D-1" SERIES, 3M, HS	TBD	POLE	LED		LED, 20C 700 4000K	45
SA2	TWIN POLE MOUNTED LED AREA LUMINAIRES TYPE III DISTRIBUTION (AT 180 D.), MOUNTED @+25'	LITHONIA "D-1" SERIES, 3M, HS	TBD	POLE	LED		LED, 20C 700 4000K	90
SB	POLE MOUNTED LED AREA LUMINAIRE TYPE III DISTRIBUTION, MOUNTED @ +12'	LITHONIA "D-0" SERIES, 3M, HS	TBD	POLE	LED		LED, 20C 530 4000K	35
SC	POLE MOUNTED LED AREA LUMINAIRE TYPE V DISTRIBUTION, MOUNTED @ +25'	LITHONIA "D-1" SERIES, T5M	TBD	POLE	LED		LED, 60C 1000 4000K	209
SD	8 X 8 X 5 INCH SURFACE MOUNTED LED AREA LUMINAIRE WALL MOUNTED @ + 12' ABOVE GRADE OR STEP, U.O.N. - CENTER OVER DOOR(S).	BEGA "22 256" SERIES	TBD	SURFACE	LED	120	LED, 1124LM, 3000K	26
SF	POLE MOUNTED LED COBRAHEAD STREETLIGHT, MOUNTED @ +XX' ABOVE GRADE	CAMAS CITY STANDARD	TBD	POLE	LED		ELECTRONIC	
SG	6 INCH IN- GRADE LED 25 DEGREE ADJUSTABLE SPOTLIGHT SPOT DISTRIBUTION	HYDREL "M9410" SERIES	ALUM	IN- GRADE	LED	120	LED, 4000K	
SH	23 INCH (DIA.) POLE MOUNTED POST-TOP LED LUMINAIRE, DISTRIBUTION TYPE II MOUNTED @ +16' ABOVE GRADE	CREE "ARE-EDR" SERIES	TBD	POLE	LED		LED, 7554LM, 6000K	90
DN	6 INCH (DIA.) X 10.5 LED DOWNLIGHT WITH 20 DEGREE BEAM	GOATHAM "ICO 6AR" SERIES	TBD	RECESSED	LED		LED, 5000LM, 3000, 20 DEG.	75



SHARP DRIVE - LIGHTING

SCALE: 1" = 60'-0"

